


COLOUR KEY	
EFFLUENT	—
CHEMICALS	—
SLUDGE	—
WATER	—
AIR	—

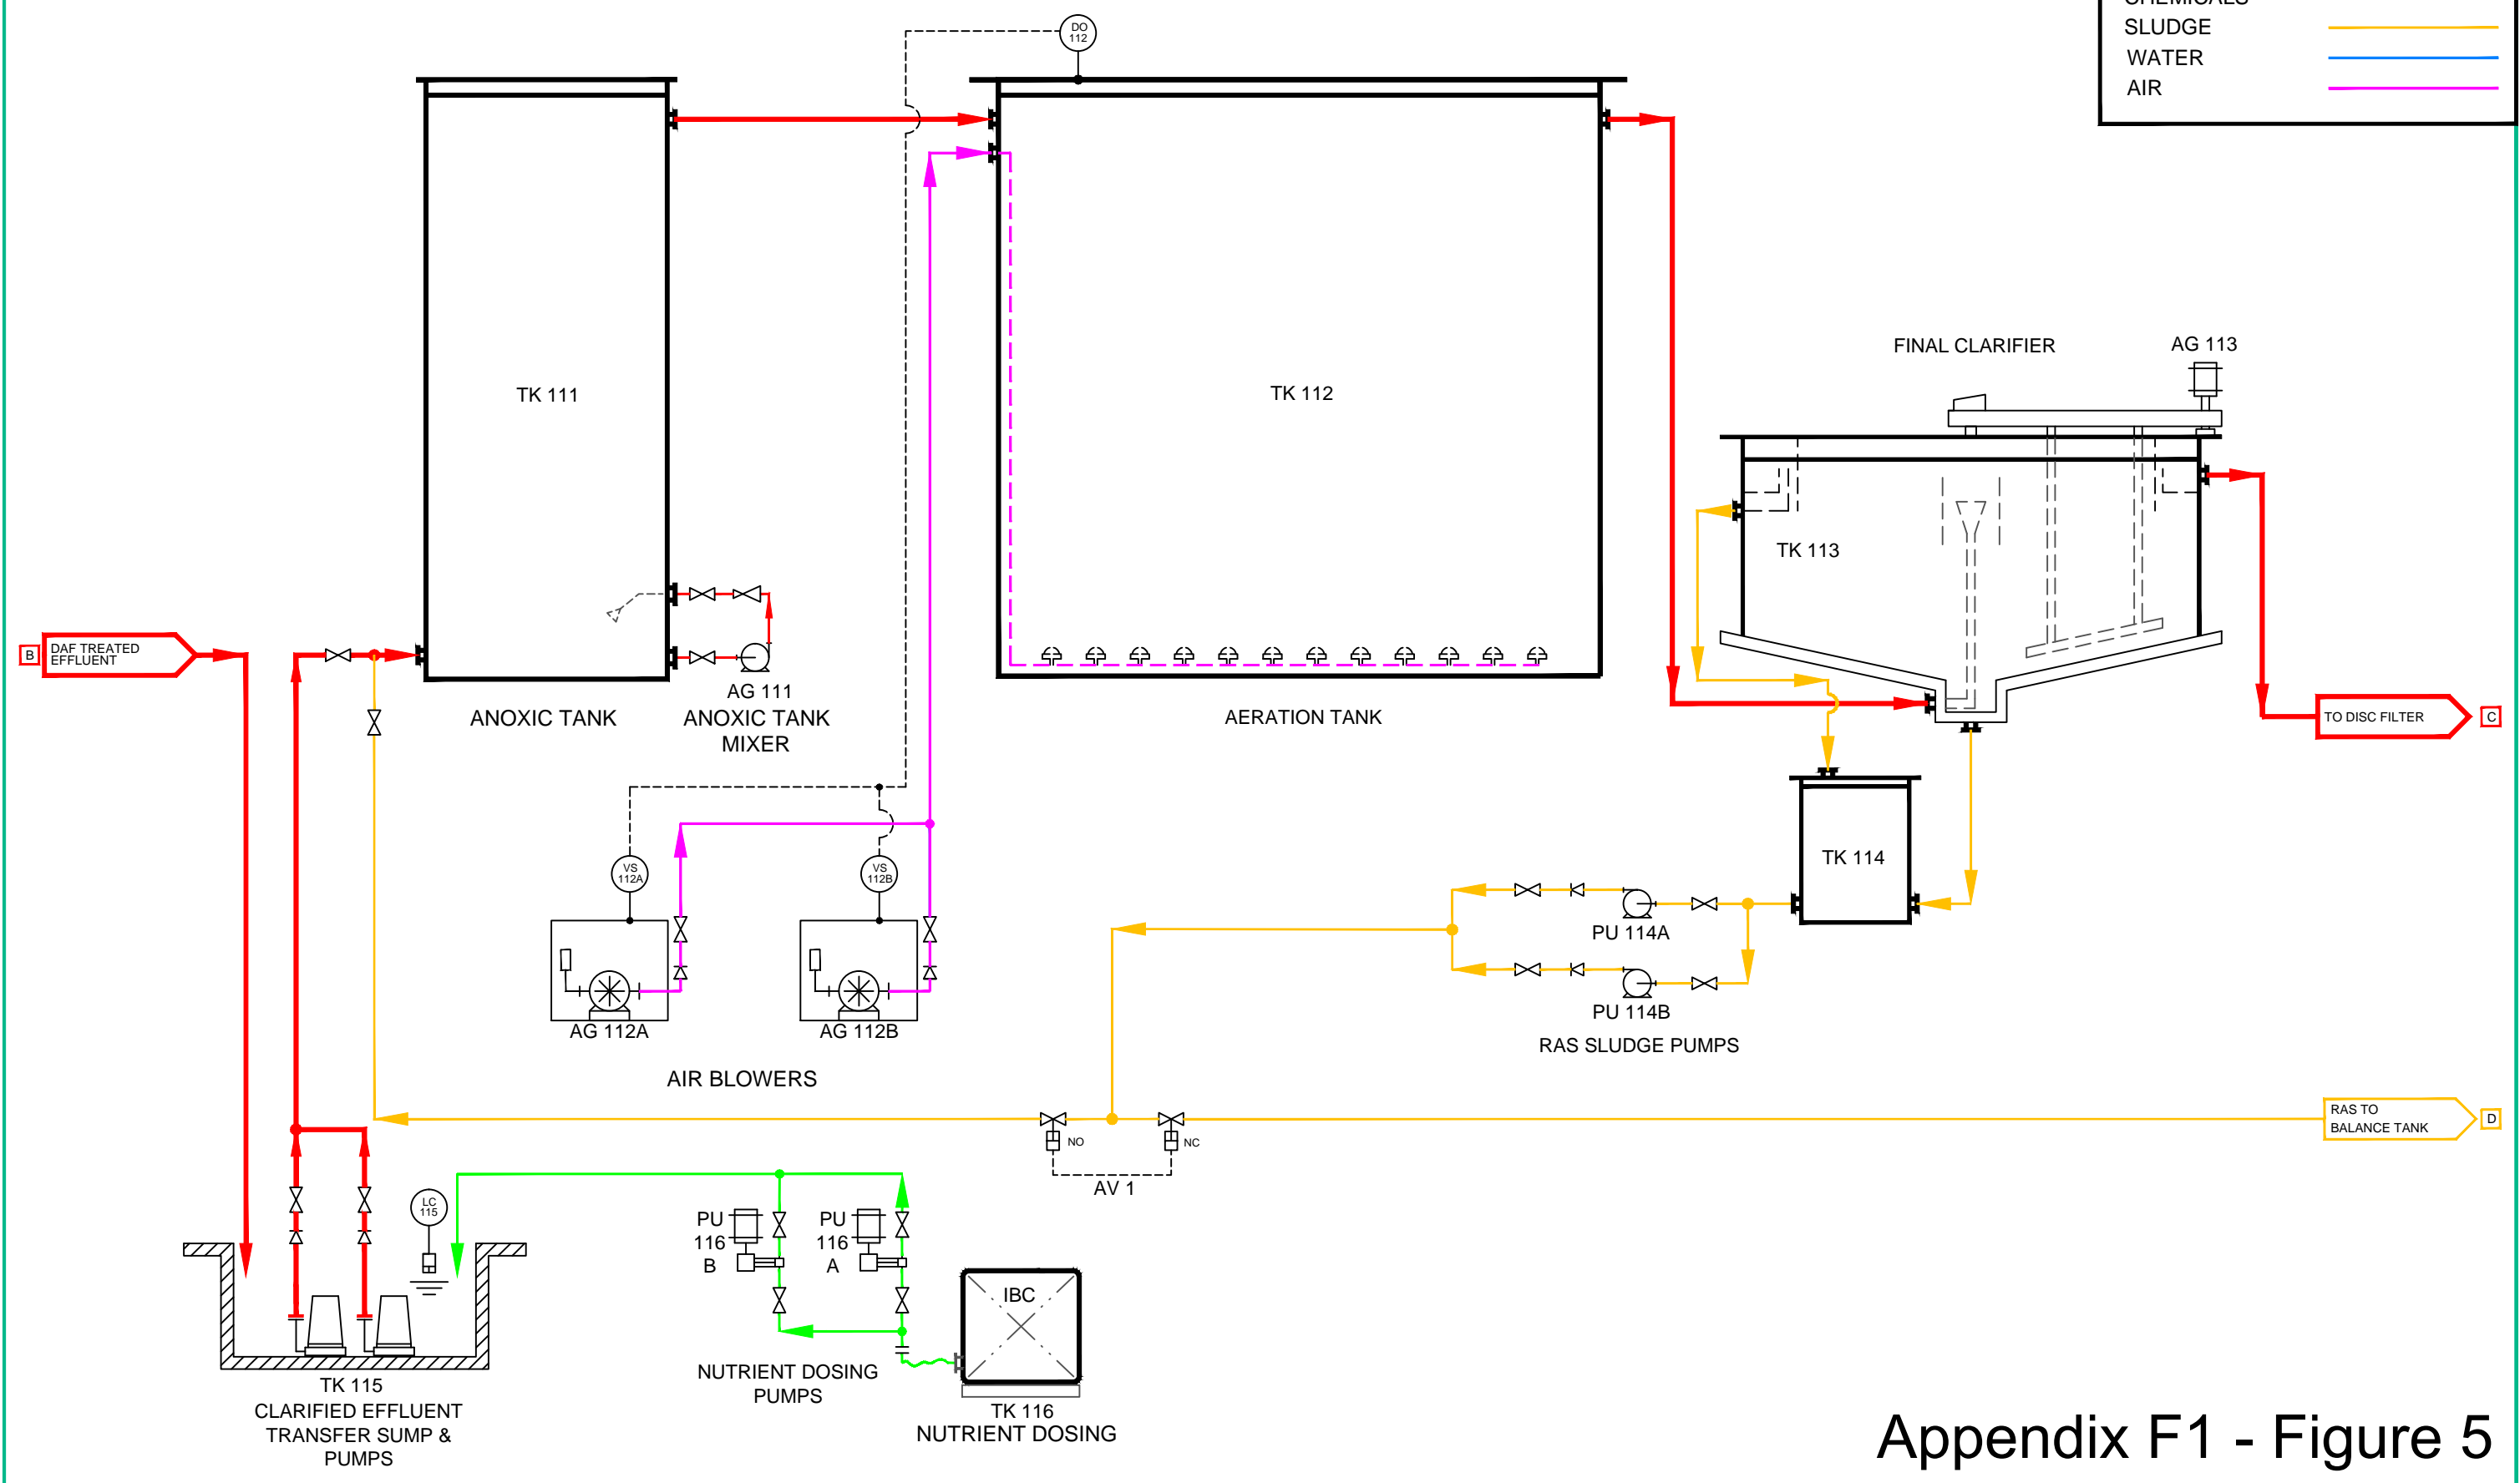

Appendix F1 - Figure 5

REV	DATE	BY	DESCRIPTION	REV	DATE	BY	DESCRIPTION
D	06.06.16	AS	WATER RECOVERY ADDED				
C	03.07.15	AS	REVISED				
B	19.01.16	DL	REVISED				
A	11.01.16	AS	FIRST ISSUE				

This drawing is issued on the condition that it is not copied in full or in part, or its contents communicated to any party without first obtaining the permission of CAP Technology Ltd


 Unit 4a, Hampton Heath Ind. Est.,
 Malpas, Cheshire. SY14 8LU
 Tel: 01948 820317 Fax: 01948 820578

DIMENSIONS IN MILLIMETERS
 UNLESS OTHERWISE STATED
 Untoleranced Dimensions
 Fabrication ± 1mm
 Machining ± 0.1mm
 Angular ± 1/2°

MATERIAL	N/A
FINISH	N/A
SCALE	N/A
DWG. SIZE	A3
DRAWN BY	A Shackleton
DATE	11.01.16
CHECKED BY	

TITLE		CLIENT		CONTRACT NUMBER		DRAWING NUMBER		SHEET		REV	
EFFLUENT TREATMENT PLANT P&ID FINAL CLARIFIER		SALISBURY POULTRY		--		SBP-003		3 Of 4		D	