


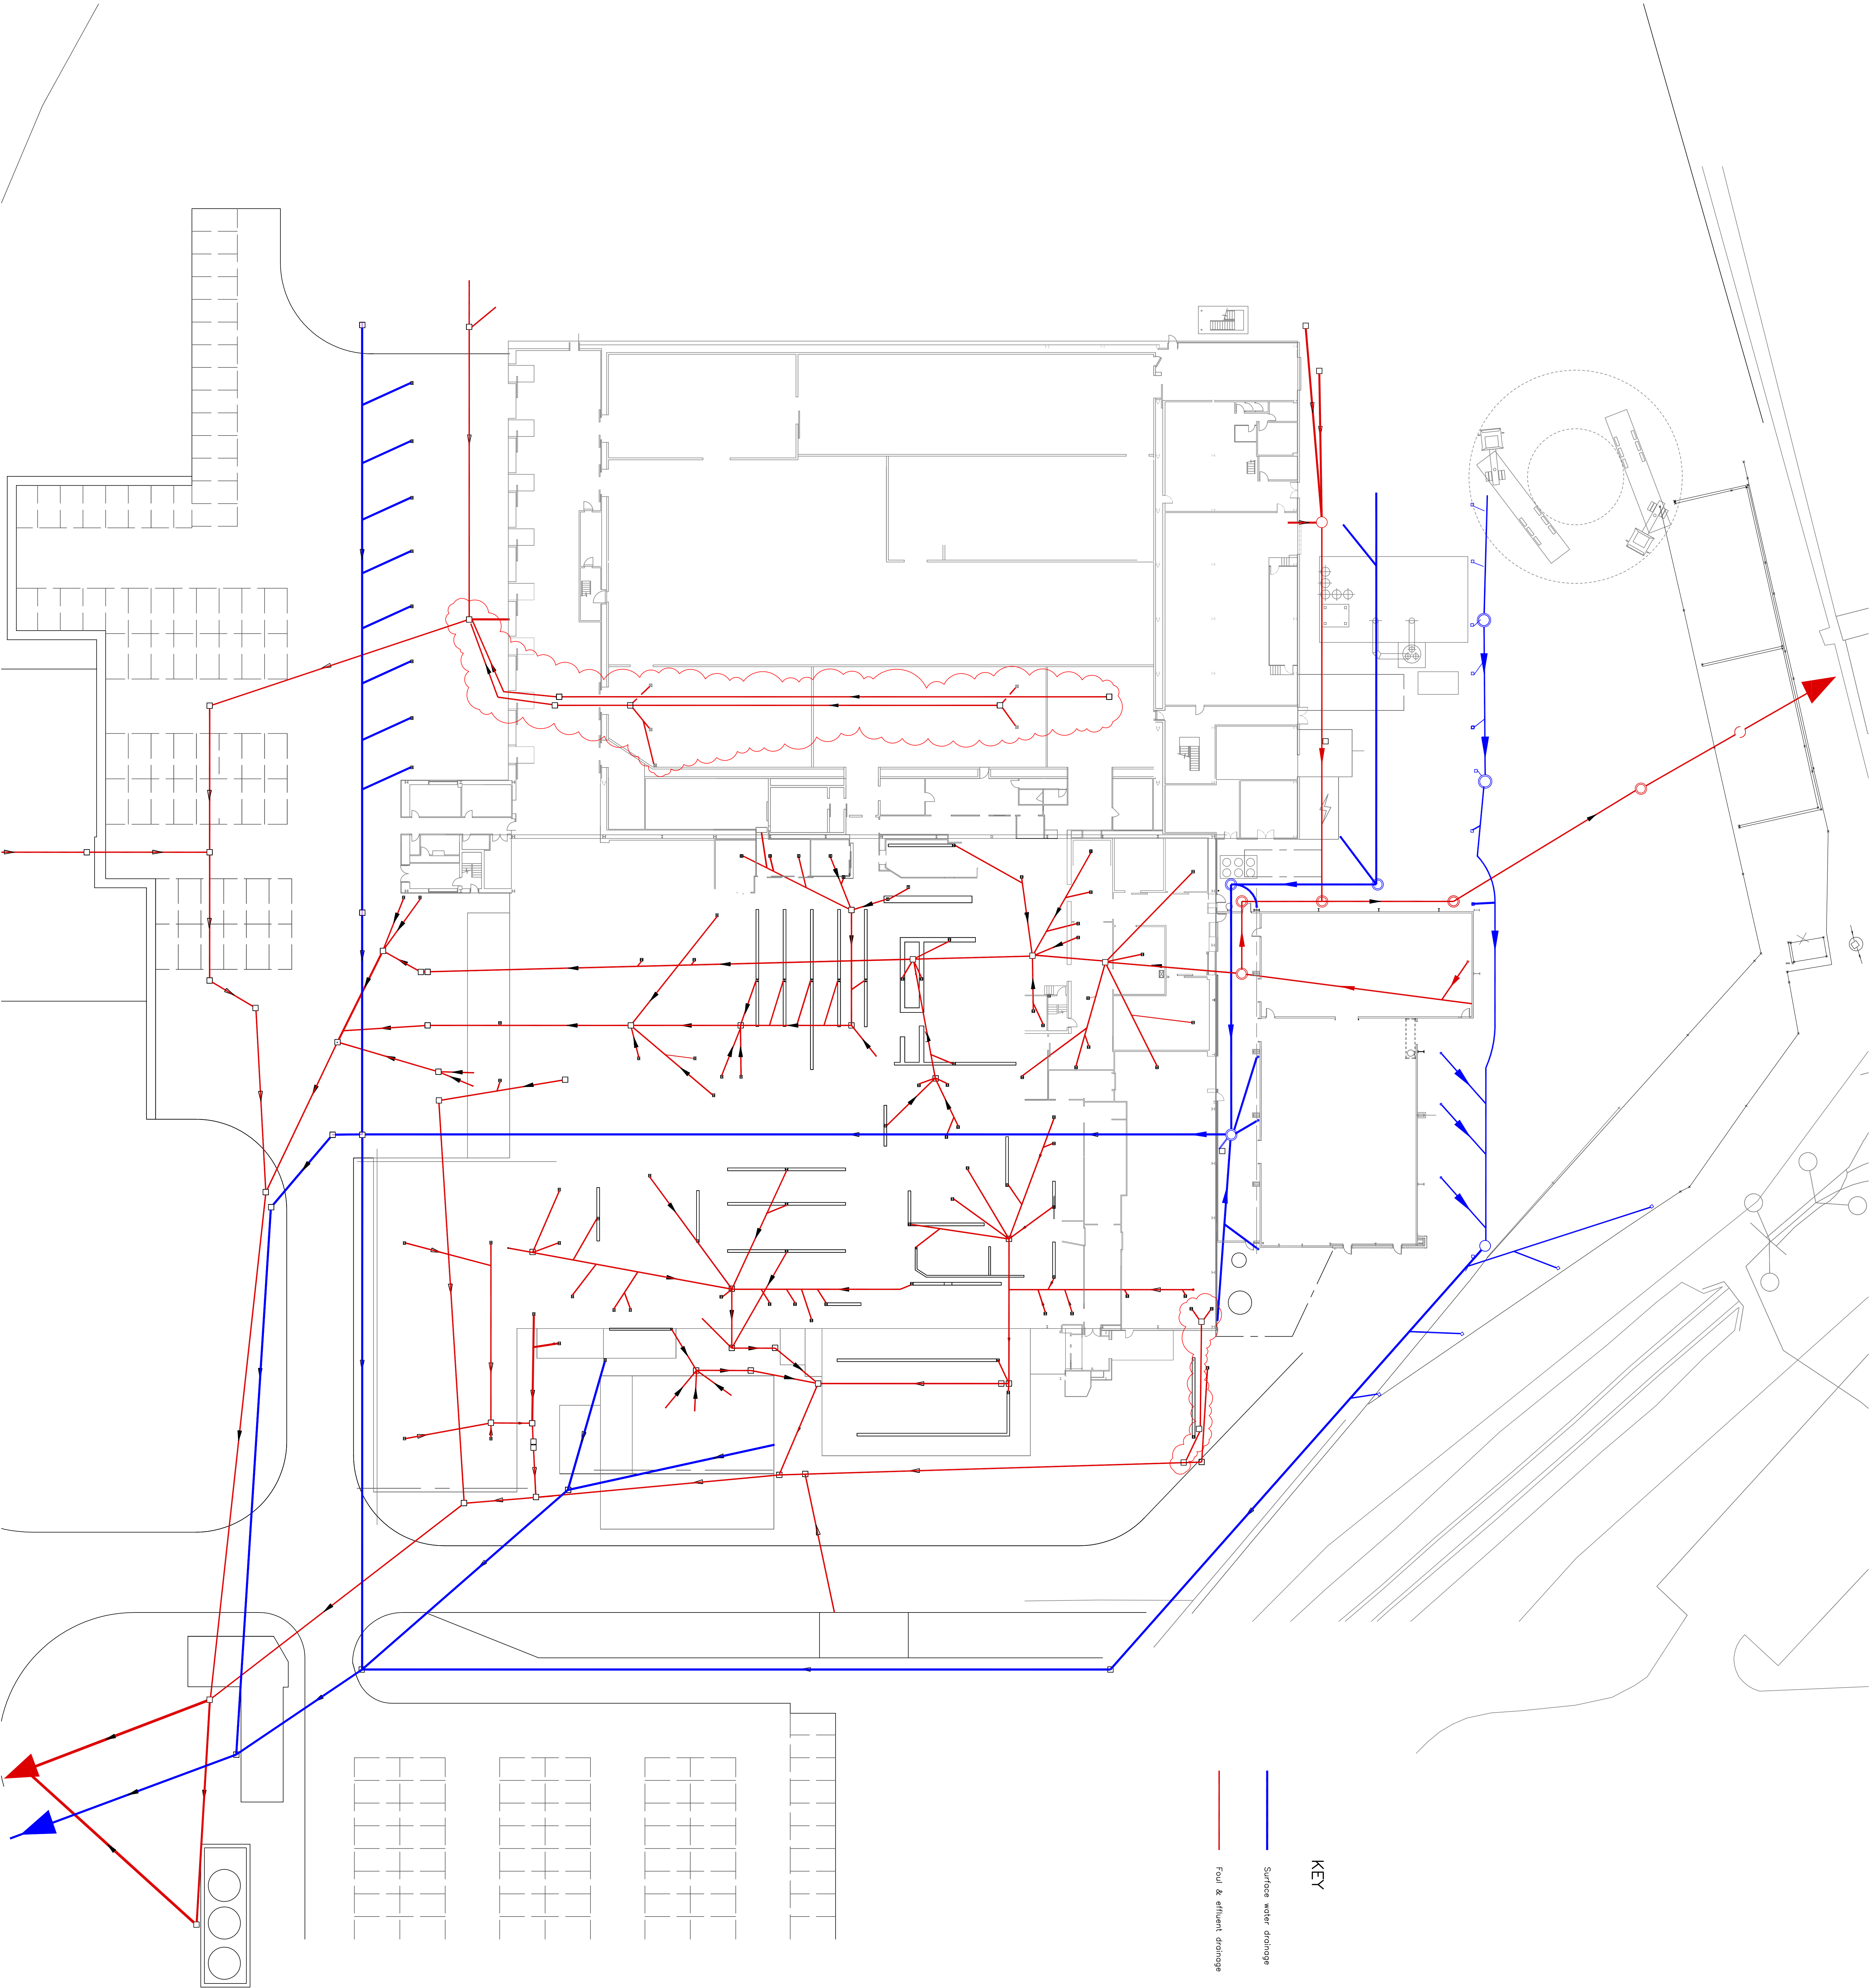

PROJECT		ROMAN FOODS LTD			
TITLE		FULL SITE PHASE 1 DRAINAGE LAYOUT			
NO	SCALE	DATE	DRAWN	CHECKED	
1:250		13.01.14	LEL	JMR	
Rigby and Partners LLP					
Consulting Civil and Structural Engineers					
19 ST. THOMAS'S ROAD, GOSPORT, HANTS, PO15 7UB					
E-mail: general@rigbyandpartners.co.uk					
PROJECT No.		DRAWING No.		REV	
P2013-033		14-1		B	