


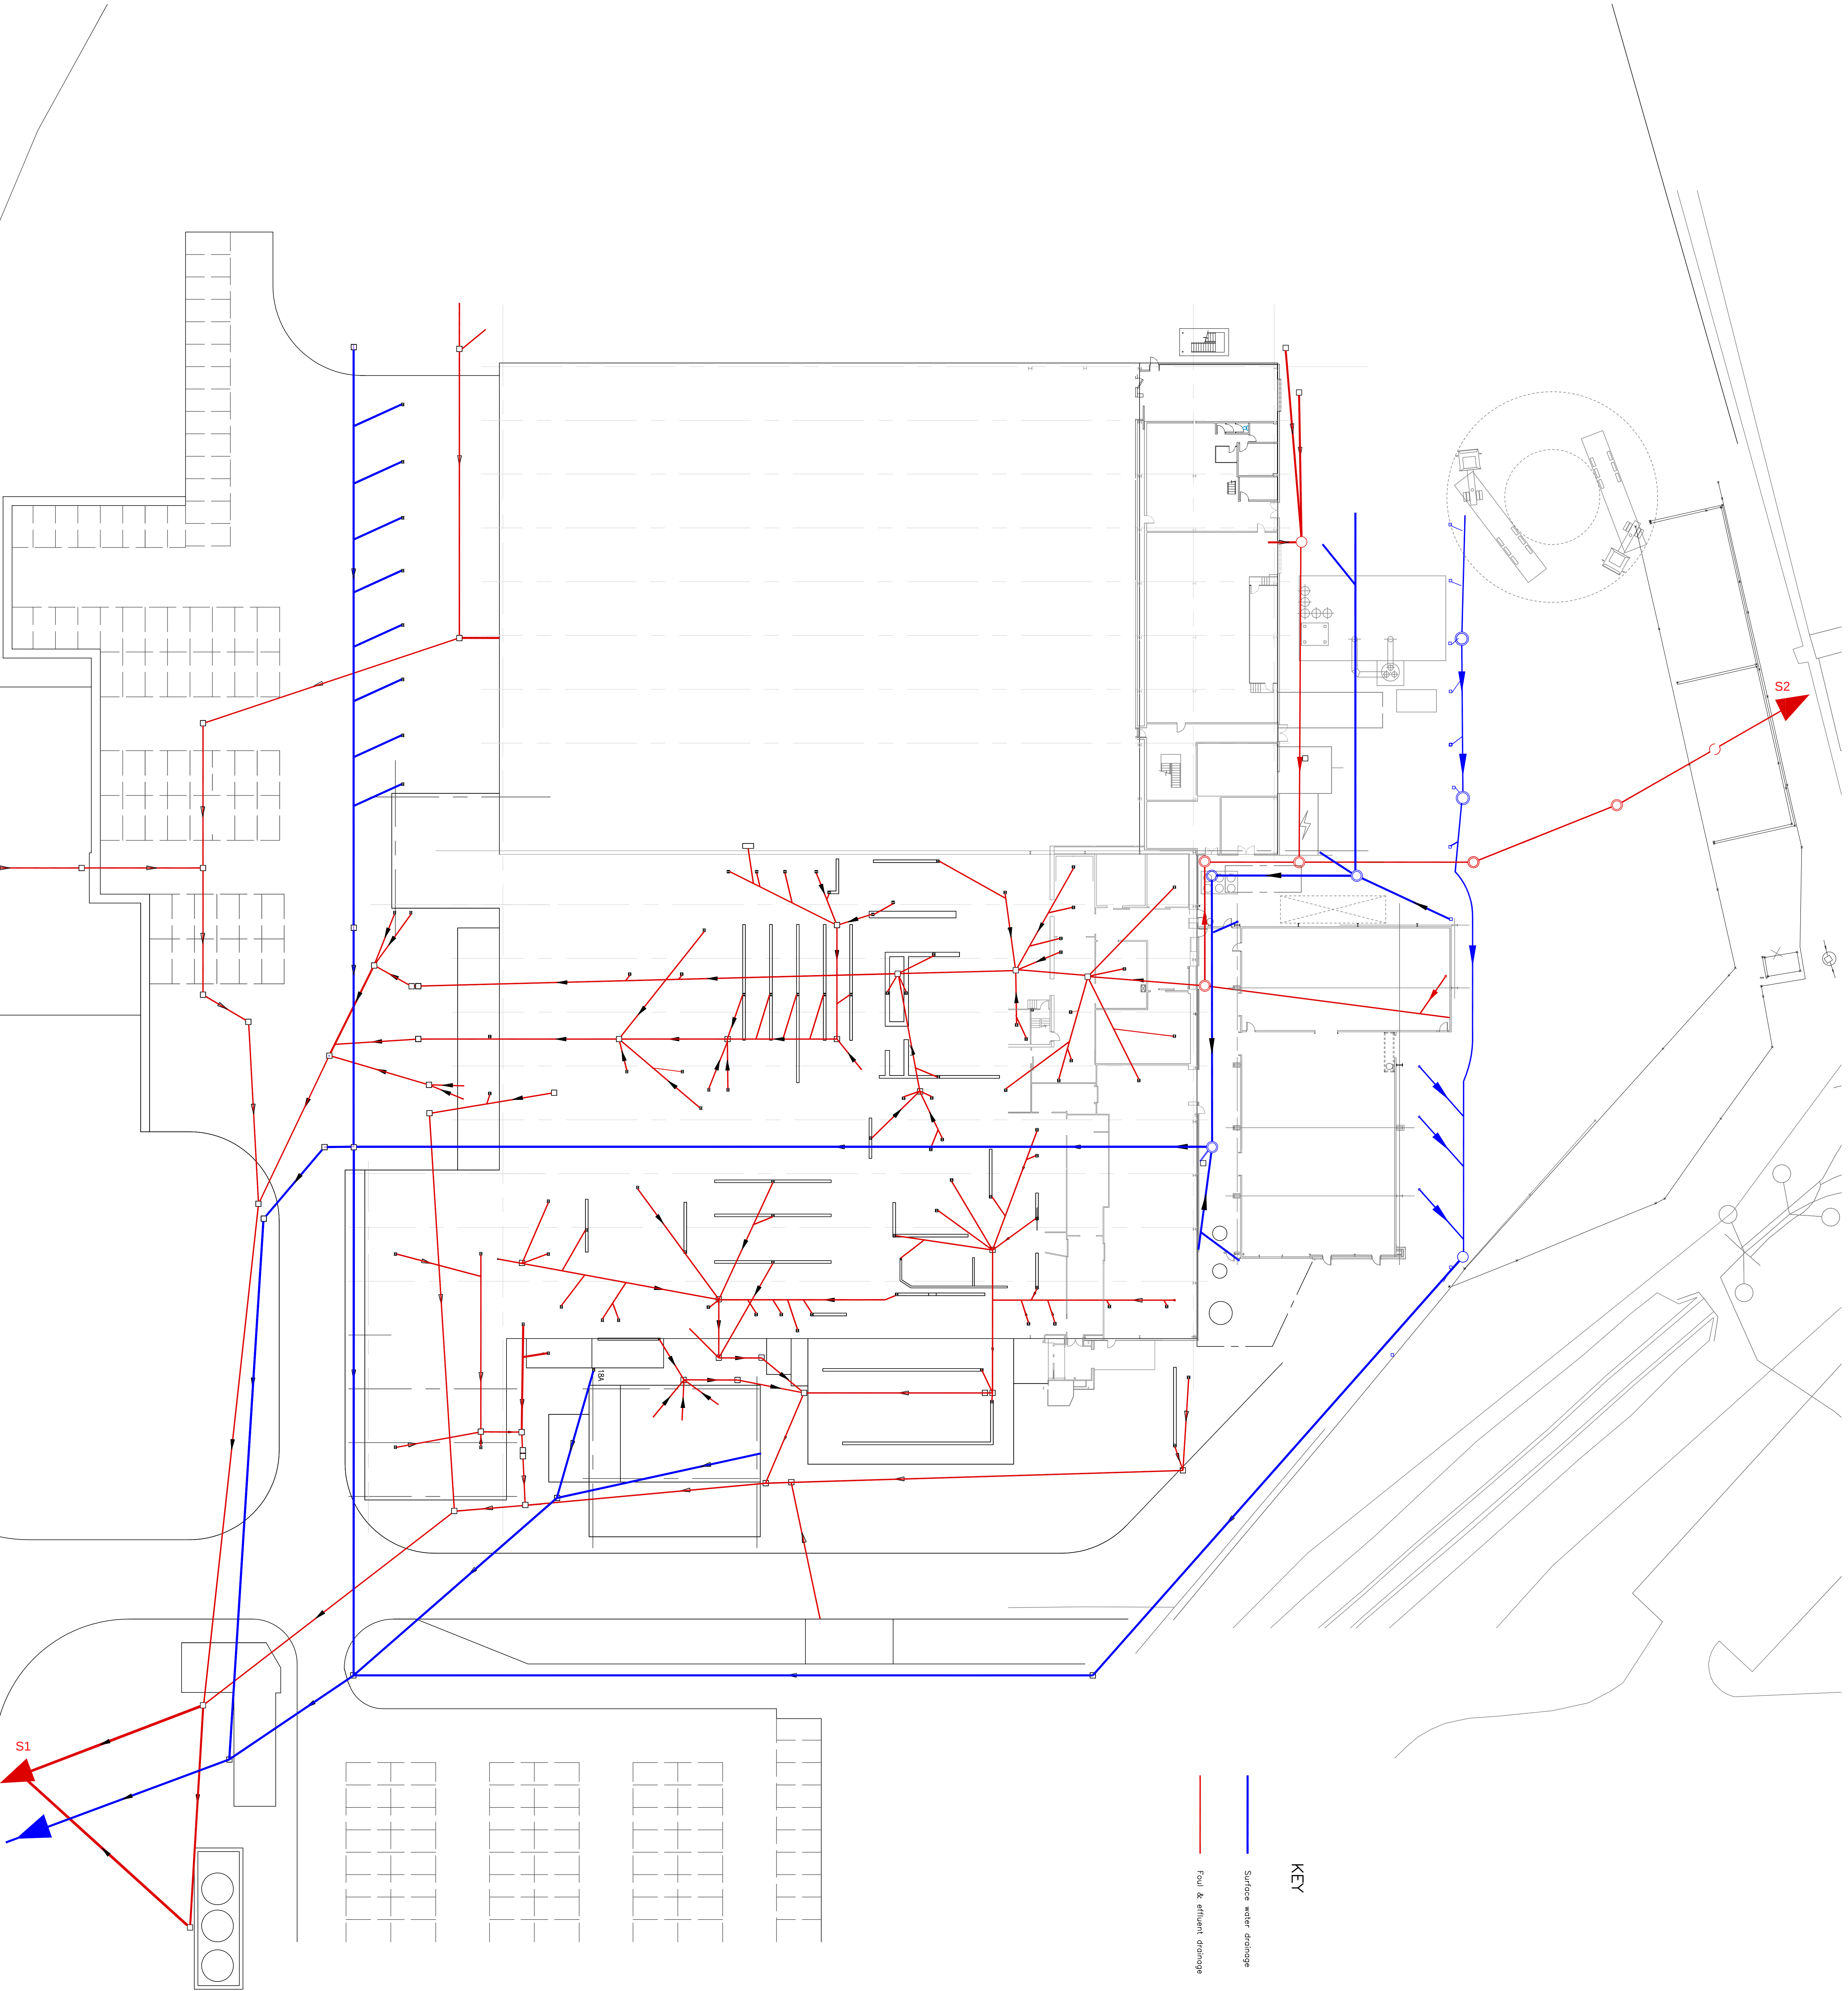

KEY

- Surface water drainage
- Foul & effluent drainage

A	PROJ ISSUE	24.03.14		02
REV	DESCRIPTION	DATE	BY	
THE CONTENT OF THIS DRAWING AND DESIGN IS OWNED BY RIGBY AND PARTNERS AND IS NOT TO BE COPIED, REPRODUCED TO A THIRD PARTY OR USED IN ANY WAY WITHOUT THE WRITTEN APPROVAL OF RIGBY AND PARTNERS.				
CLIENT ROWAN FOODS LTD ASH RD SOUTH WREXHAM IND. ESTATE				
PROJECT ROWAN FOODS LTD FULL SITE PHASE 1 DRAINAGE LAYOUT				
NO	SCALE	DATE	DRAWN	CHECKED
1:250	1:301.14	LEL	JMR	
Rigby and Partners LLP Consulting Civil and Structural Engineers 18 ST. THOMAS'S ROAD, CHELTENY, LANCOS, PR17 7HH, ENGLAND E-mail: general@rigbyandpartners.co.uk				
PROJECT No. P2013-053	DRAWING No. 14-1	REV A		