


River Severn
(Afon Hafren)

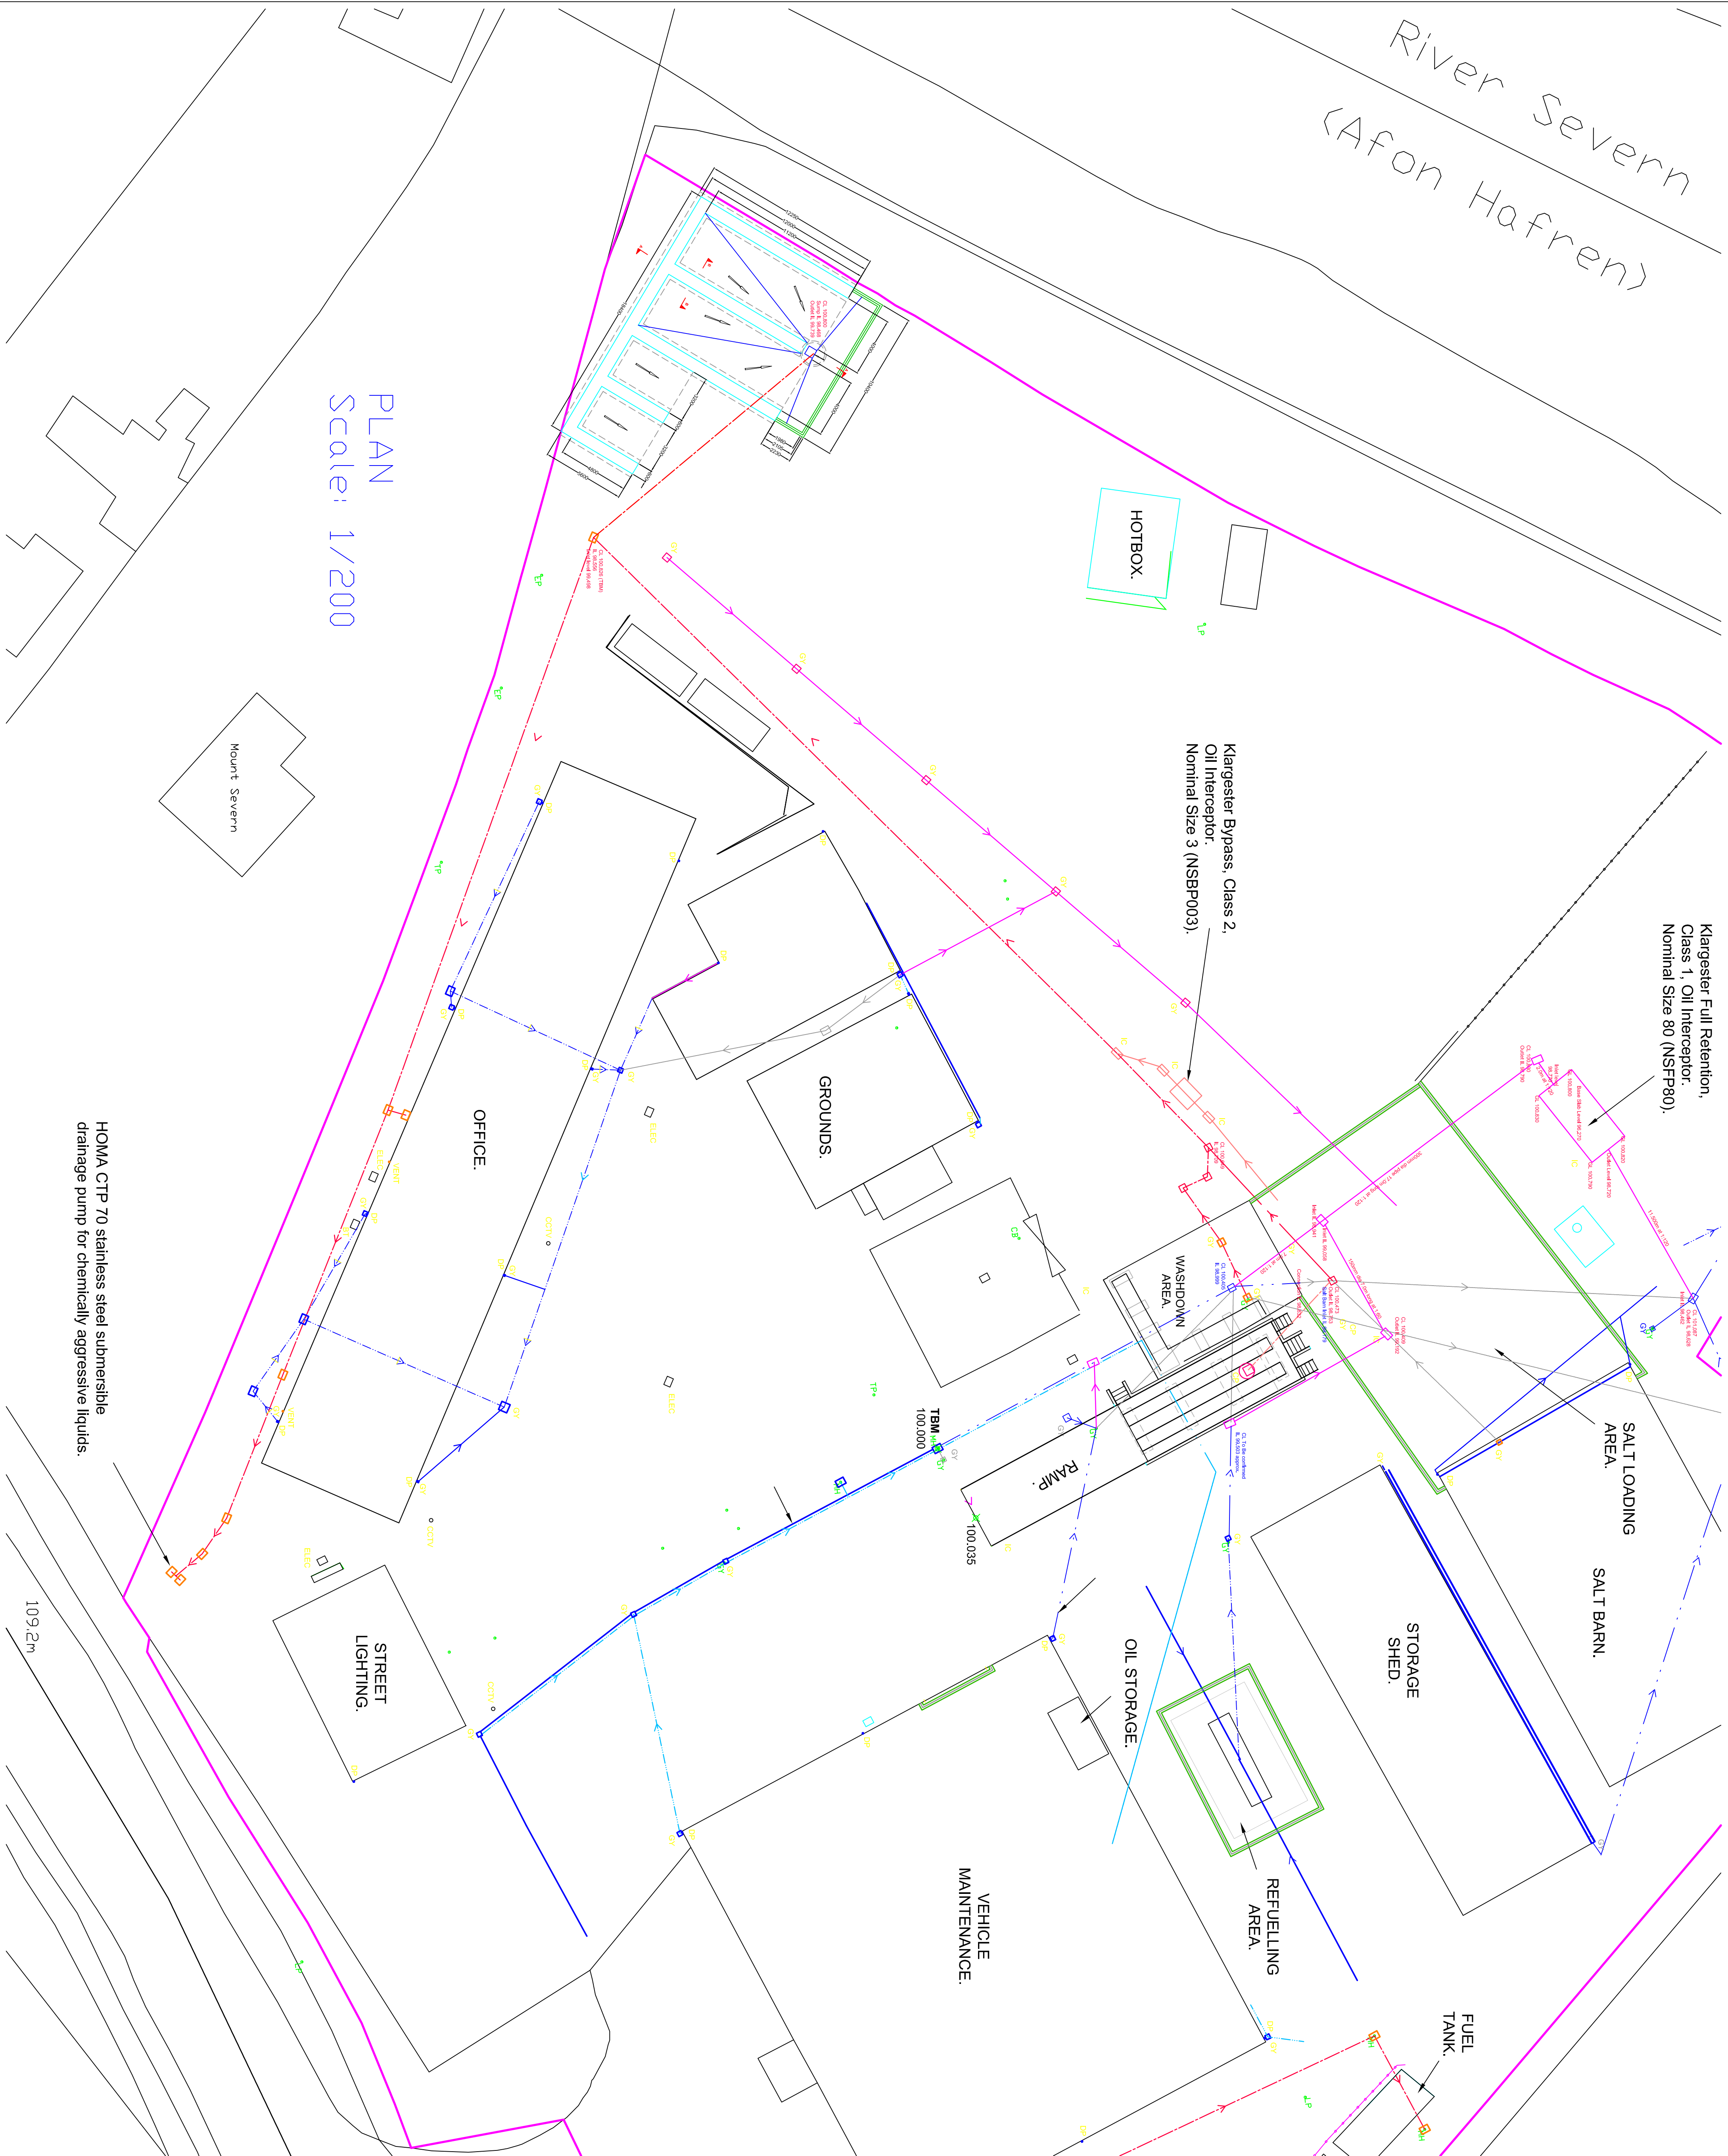

PLAN
Scale: 1/200

HOMA CTP 70 stainless steel submersible
drainage pump for chemically aggressive liquids

109.2m

[illegible]

Rev	Date	Date	By
Z	As-built	DDP	



Powys County Council

CWIC

Central Wales Inter-organism Collaboration



Ceredigion County Council

Engineering Design Services

CWIC Engineering Operations Manager : Steve Davies

Engineering Design Service Manager : John Edwards

Tel 01545 572972 Fax 01545 572889

<http://www.powys.gov.uk>

Project

Kirkhamstead Depot, Newtwnon

Drawings Title

Drainage plan

Drawings No

H2279

Drawn by

DOMB

Checked by :

03/04/2019

Scale of A1

As Noted

Project Number

H2279

C/C003

Revision

Z

Design Parameters : 275mmØ x Reinforcing Slab by 180 Zbars

Notes