


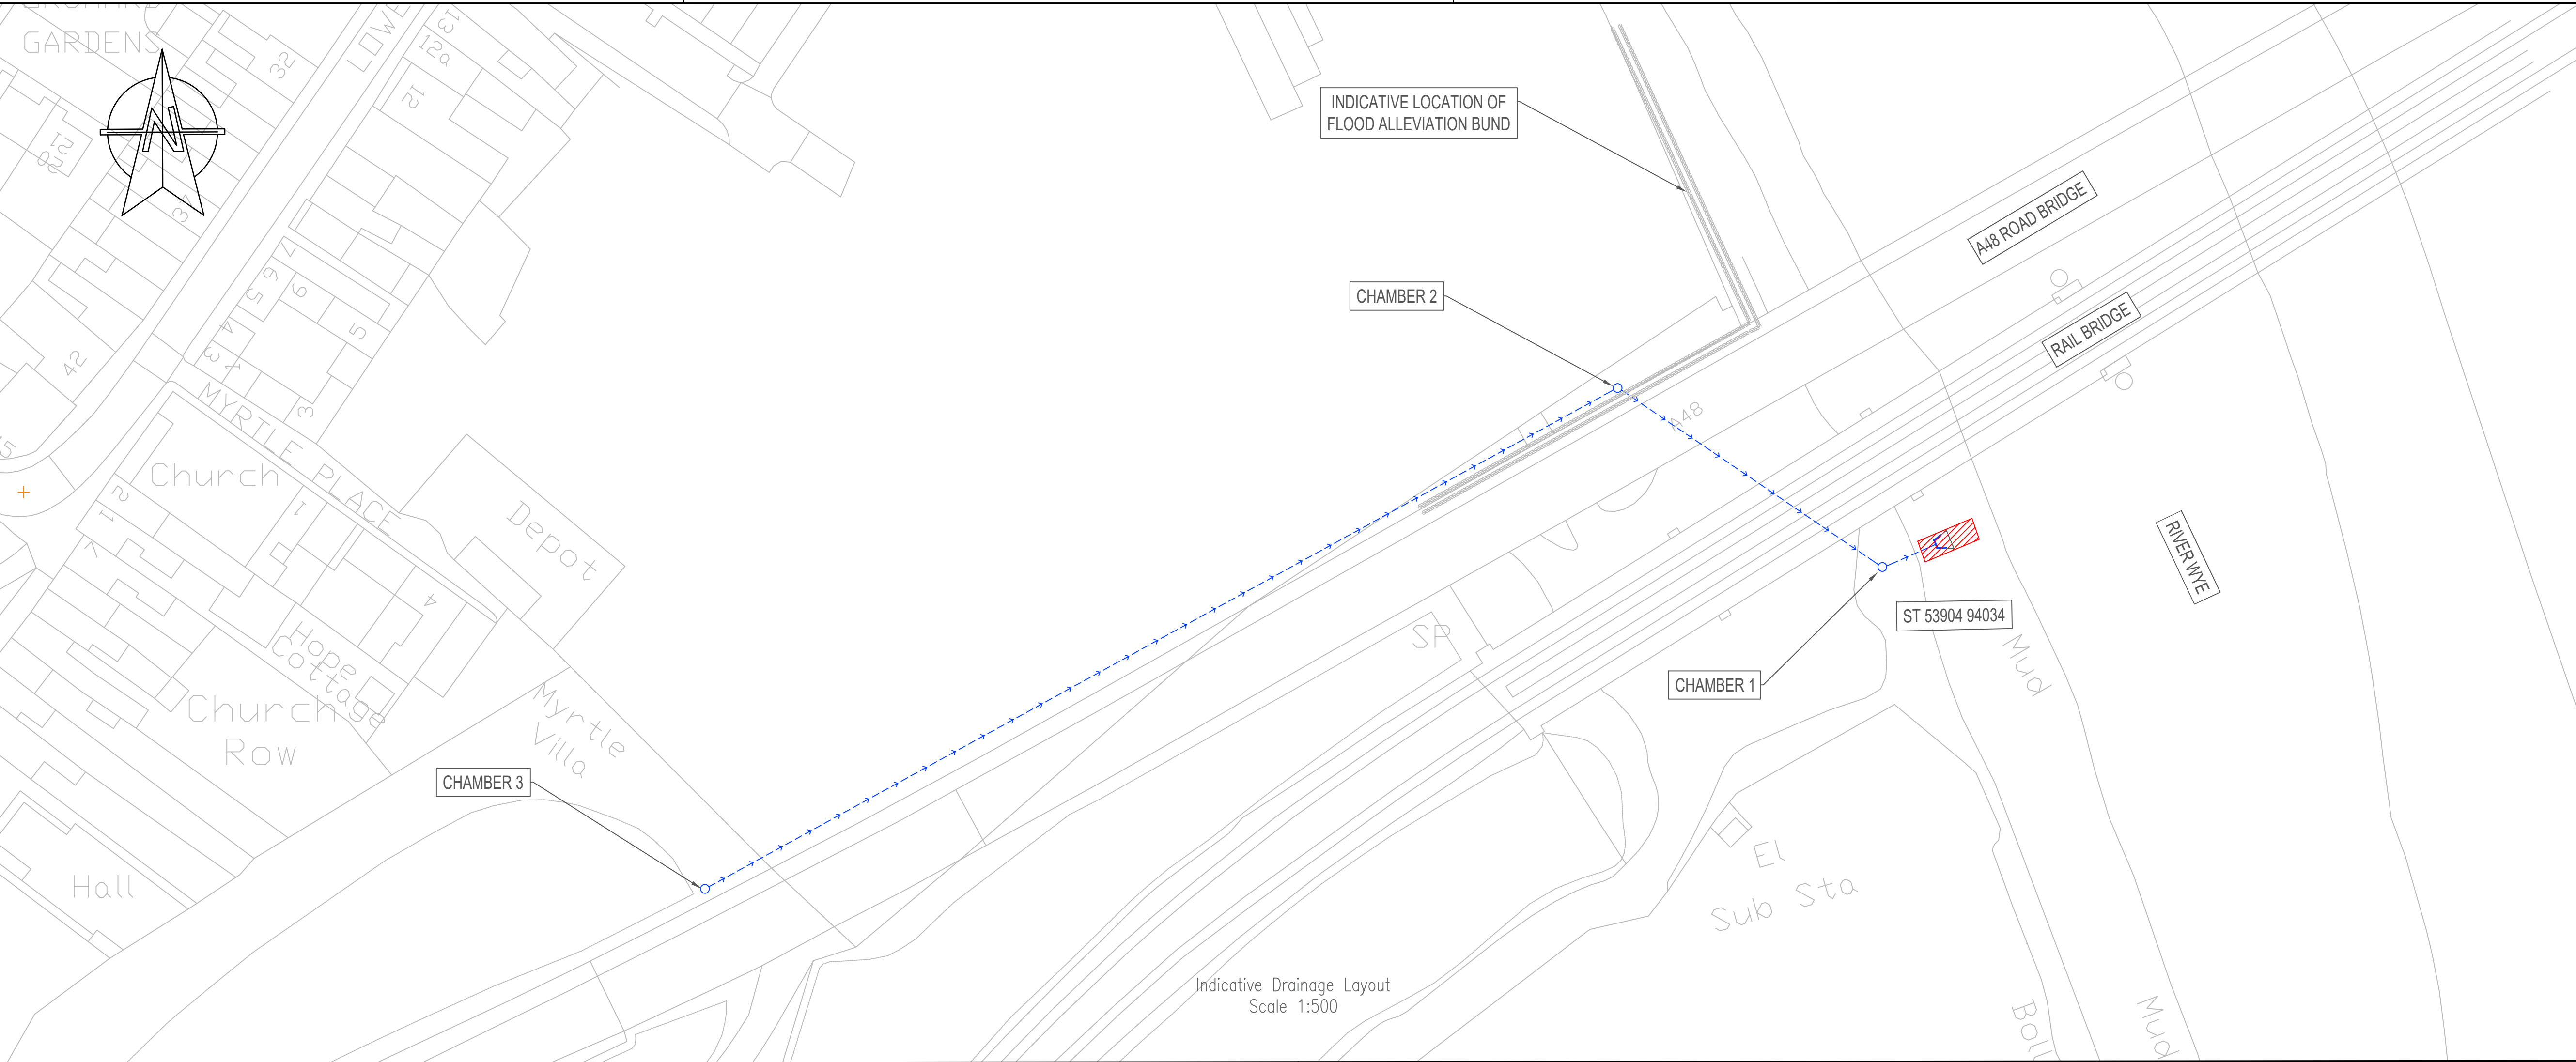

NOTES

1. ALL DIMENSIONS ARE IN METRES UNLESS STATED OTHERWISE

2. DRAINAGE LAYOUT IS INDICATIVE. EXACT LOCATION OF HEADWALL, CHAMBERS 1 AND 2 TO BE CONFIRMED IN INVESTIGATION WORKS

3. LOCATION OF FLOOD ALLEVIATION BUND IS INDICATIVE

KEY

→

EXISTING DRAINAGE RUN

○

EXISTING CHAMBER

⌋

EXISTING HEADWALL



—

EXISTING HEADWALL CONCRETE APRON

PROPOSED AREA OF EXCAVATION (8m x 3m x 2.2m)

—

EXISTING FLOOD ALLEVIATION BUND

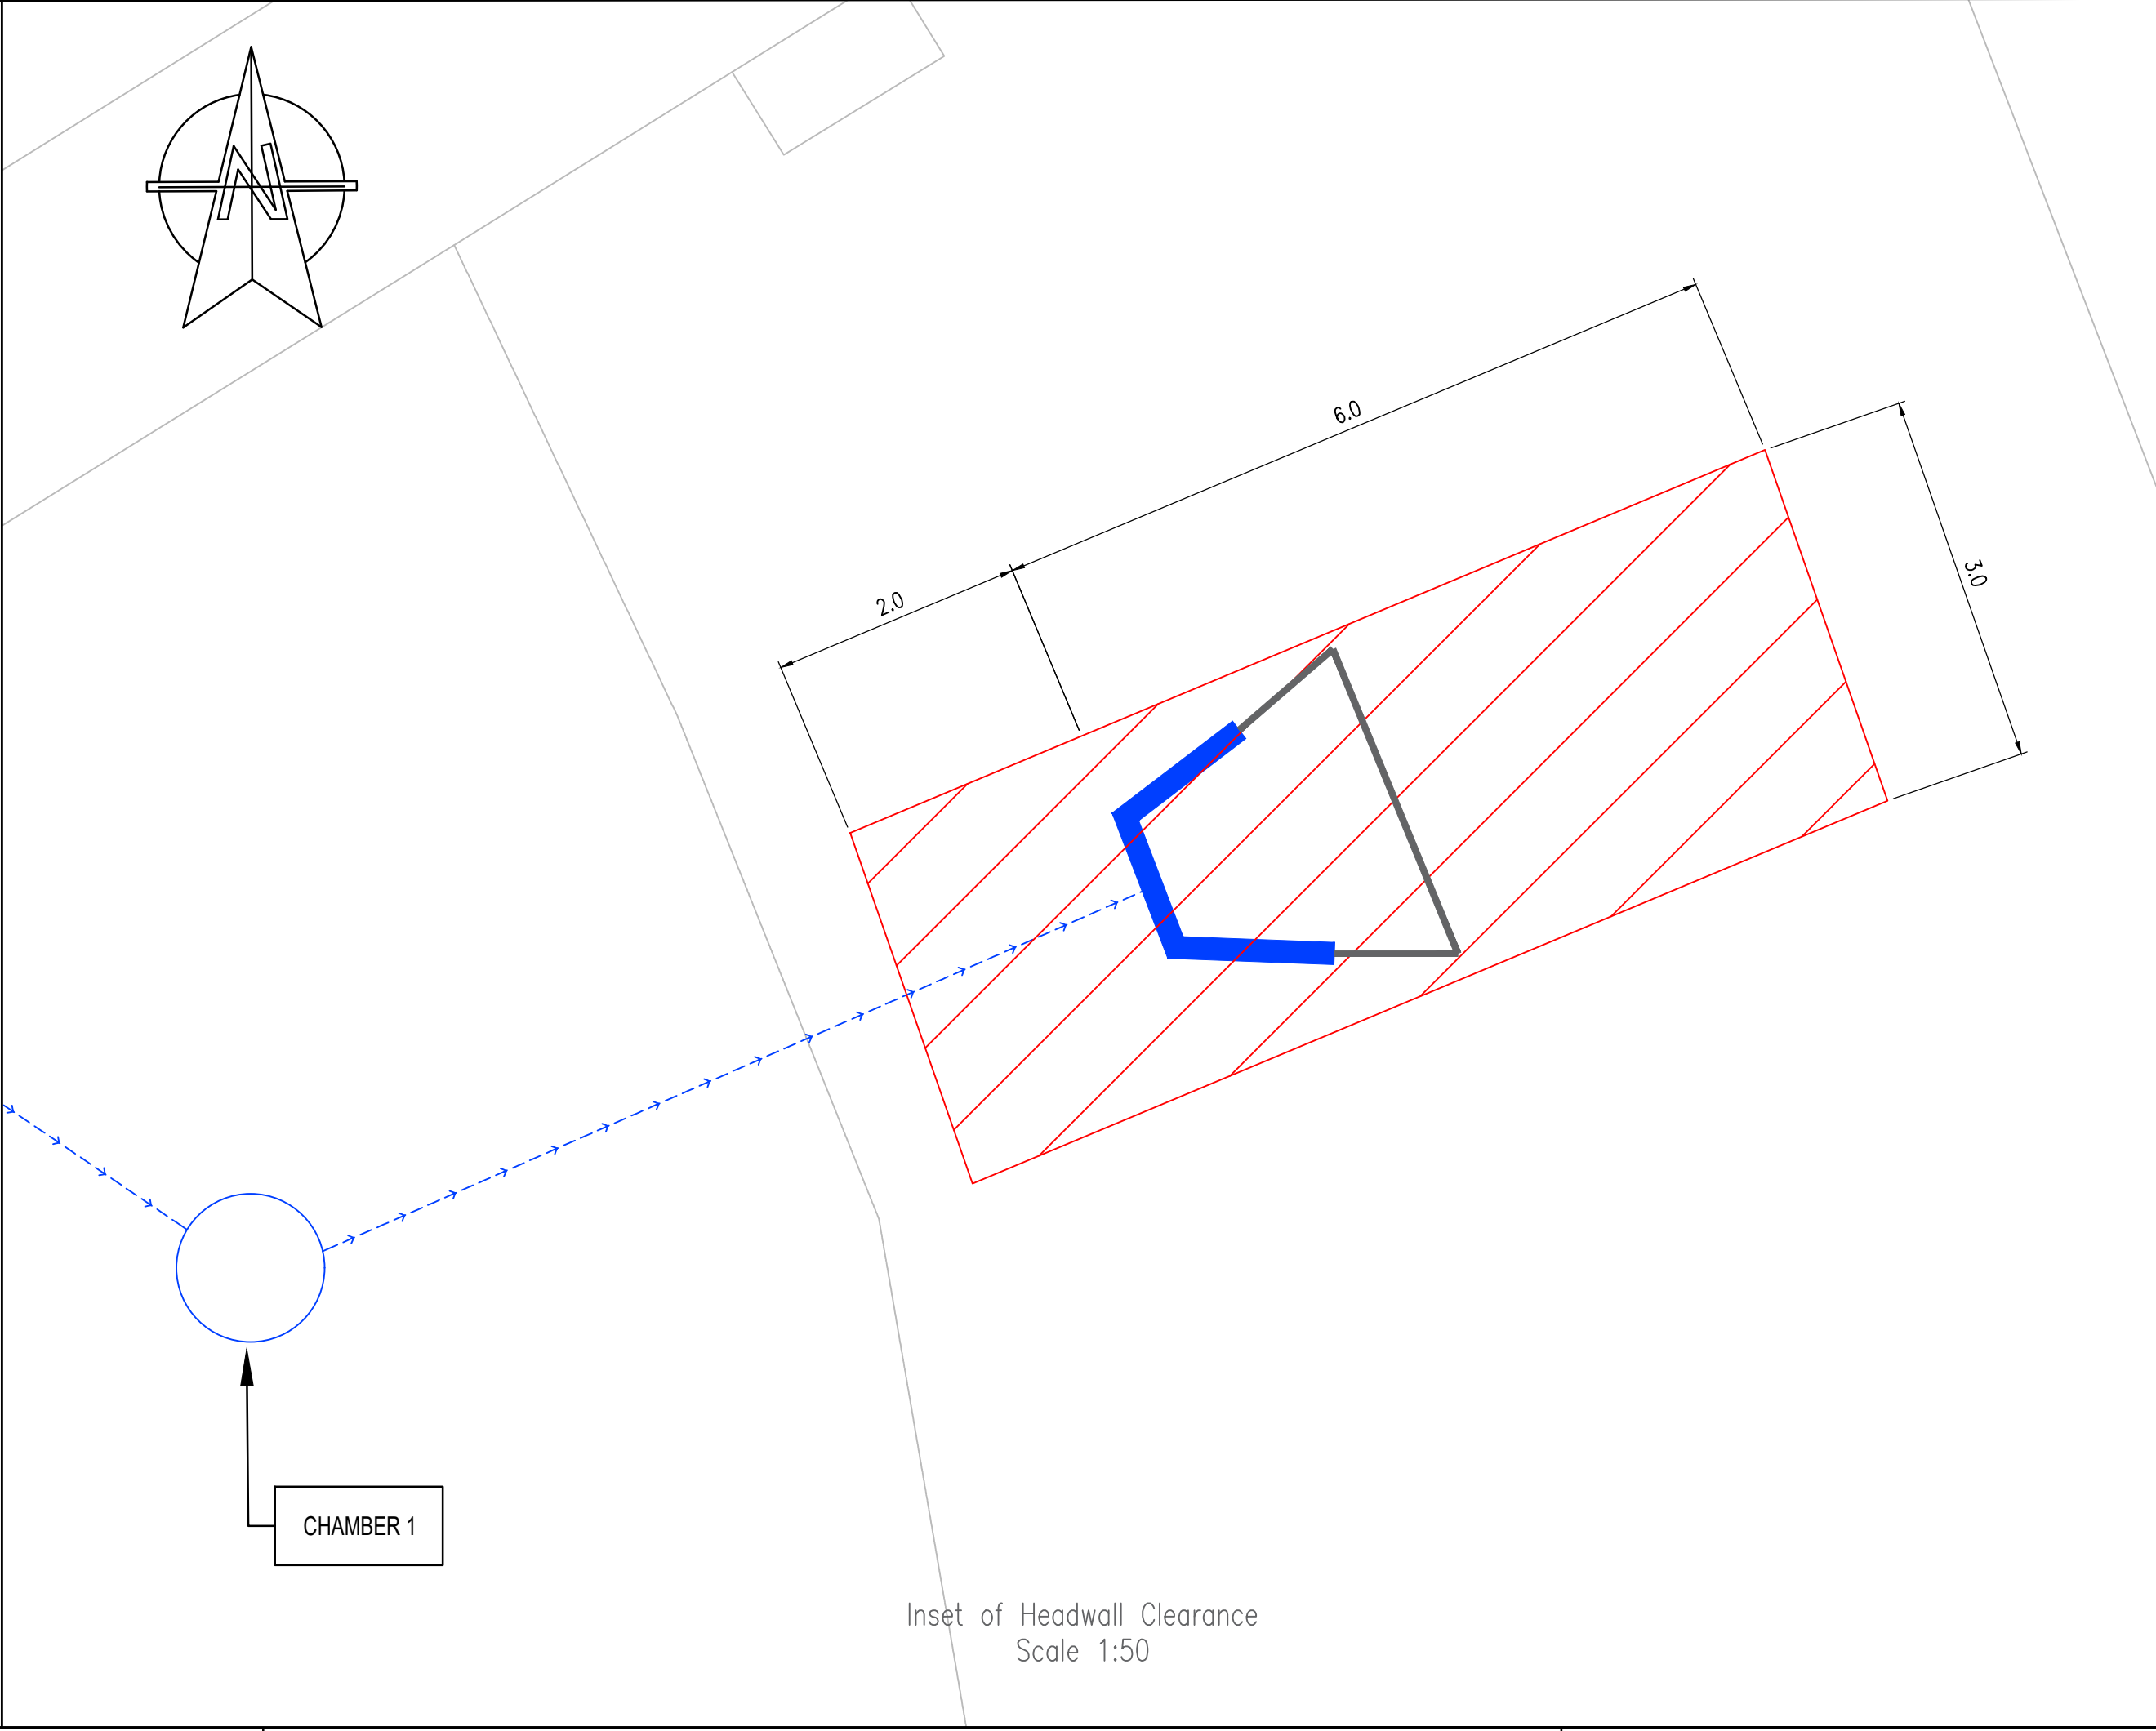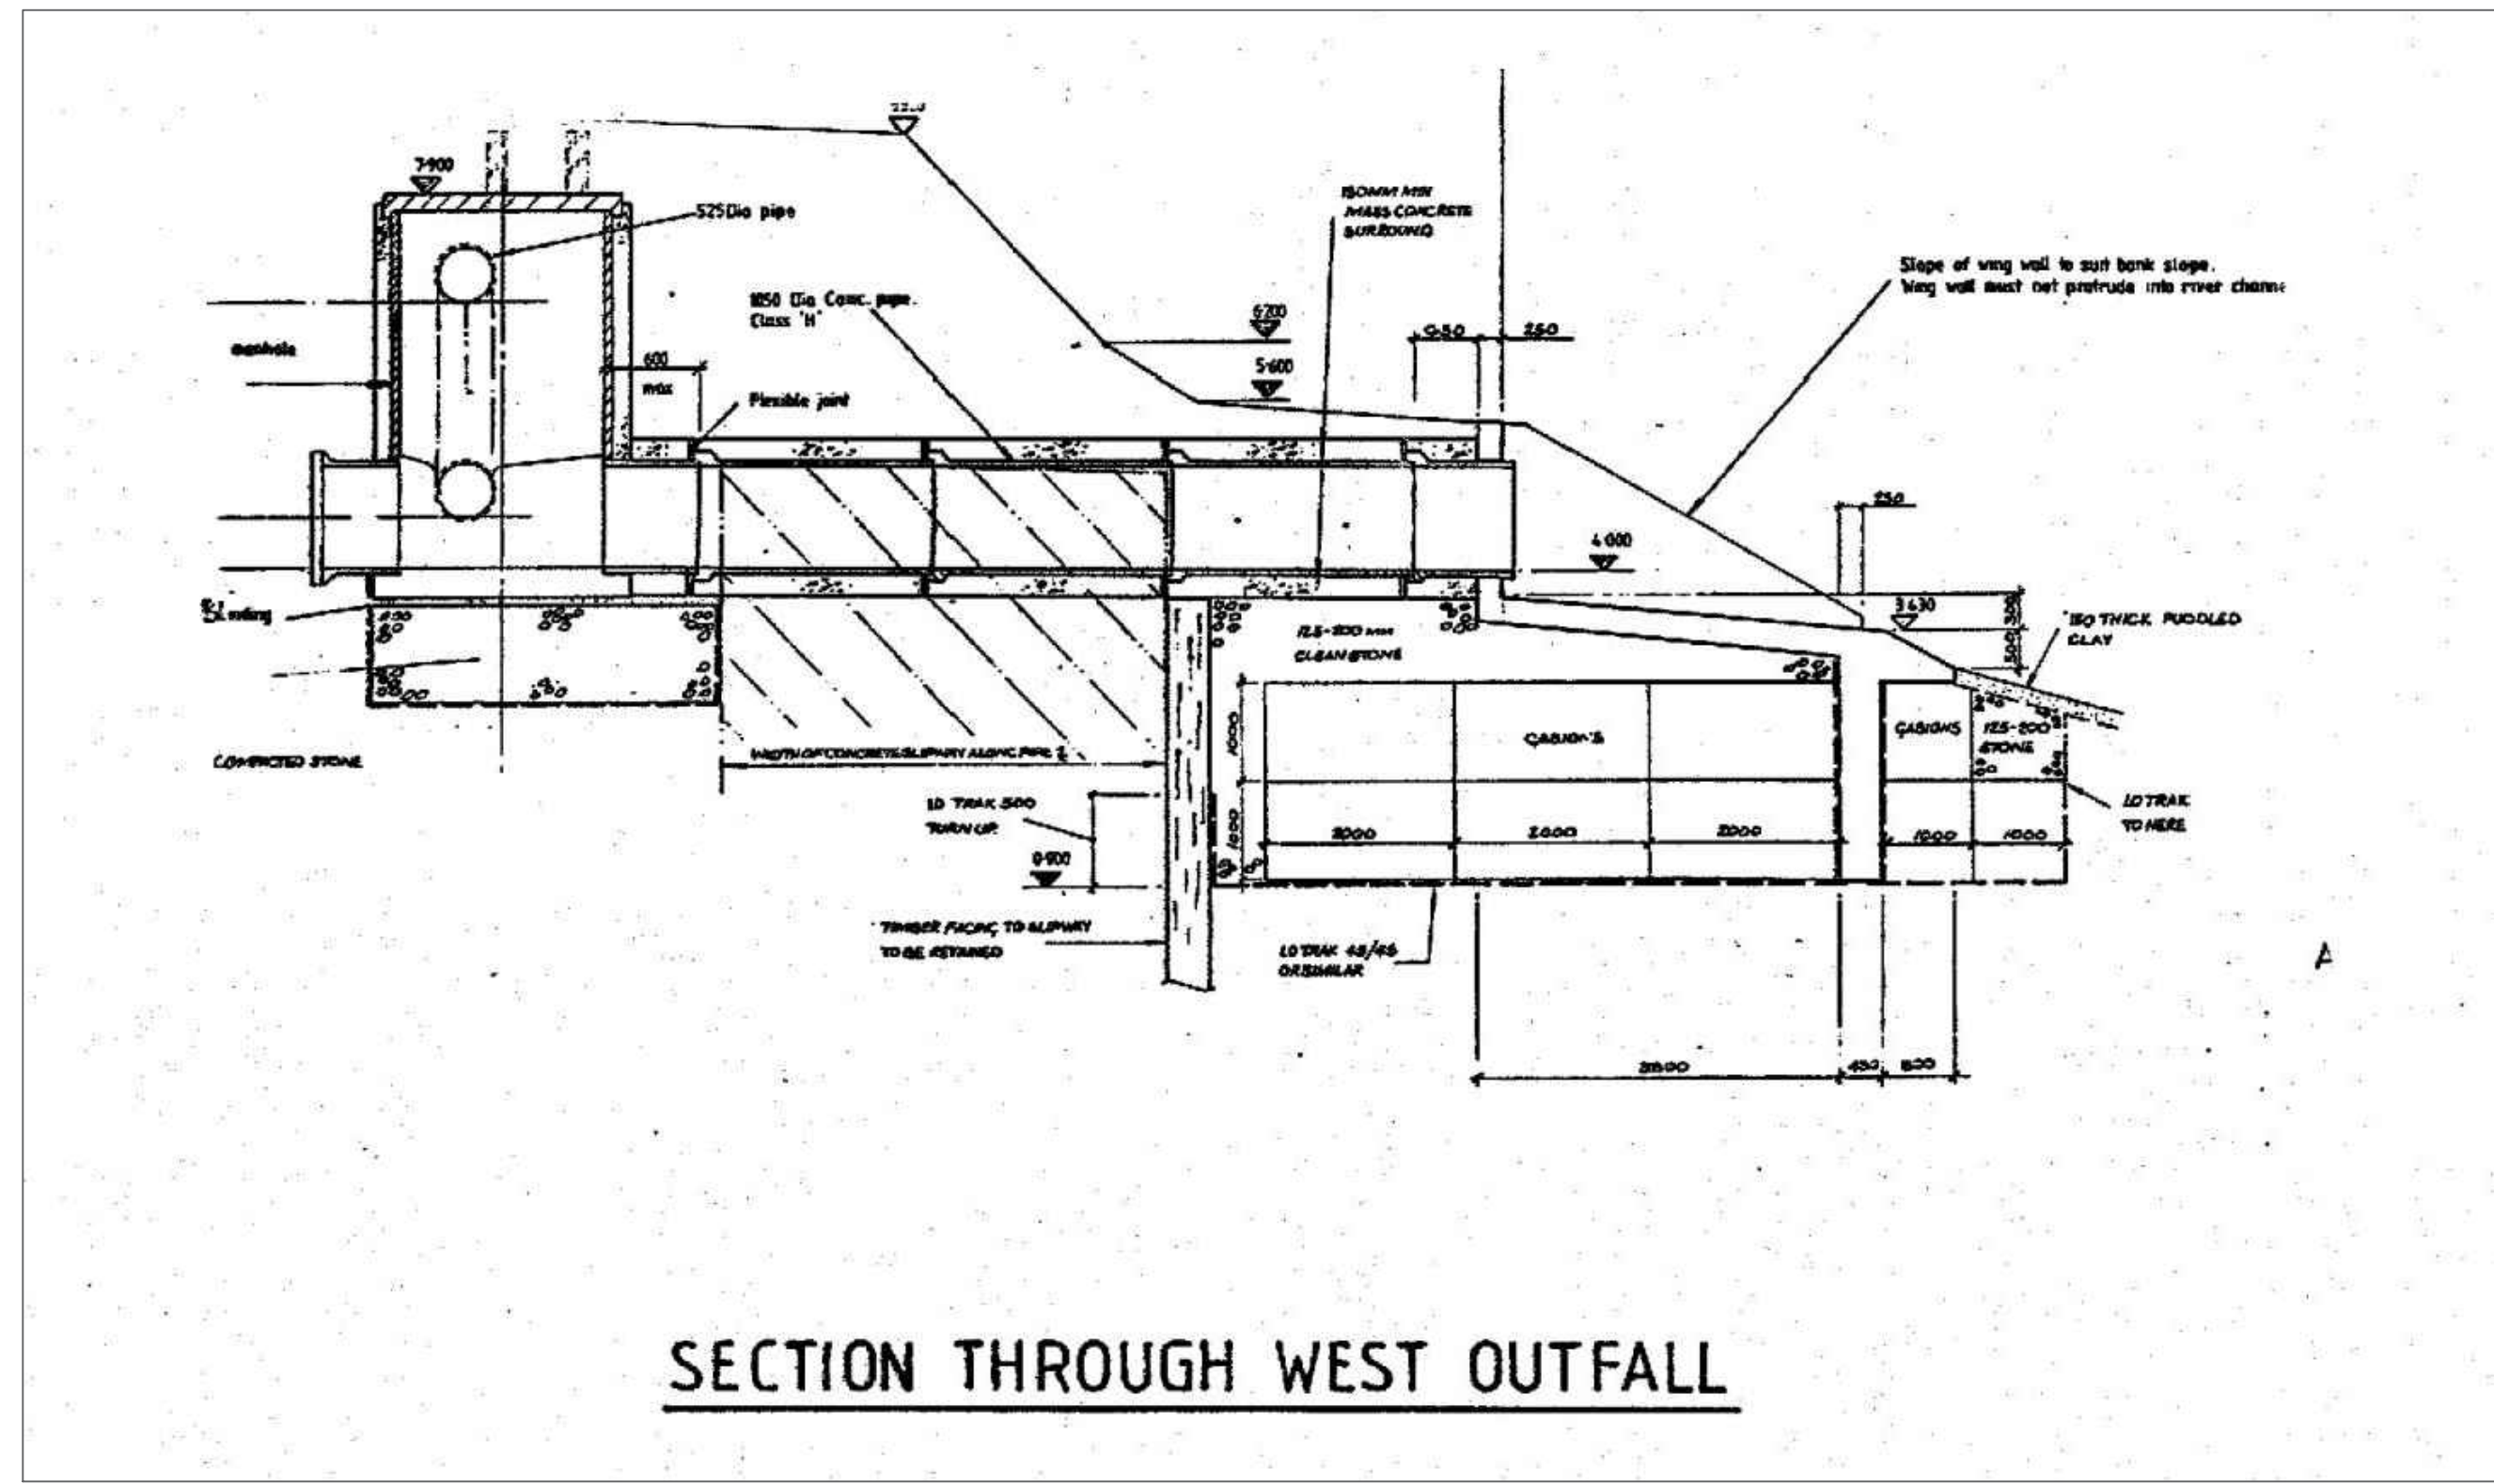

P01

FIRST ISSUE

RM

RM

AJ

26/07/23

Rev


Details

Dr

Ch

Ap

Date

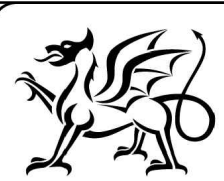

Yn gweithio ar ran

Llywodraeth Cymru

Working on behalf of the

Welsh Government



South Wales Trunk Road Agent

Asiant Cefnffyrdd De Cymru

Richard Jones BSc(Hons) C.Eng C.Env FICE FCIHT

Head of Service - Trunk Road Agent

Pennarth - Asiant Cefnffyrdd De Cymru

Unit 12, Llandarcy House

The Courtyard, Llandarcy,

Neath, SA10 6UD



1 Capital Quarter, Tyndall St, Cardiff, CF10 4BZ, UK

T+ 44 (0) 292 076 9200

wsp.com

Project

A48

WYEBRIDGE CHEPSTOW DRAINAGE

DRAINAGE INVESTIGATION AND CLEARANCE

SHEET 1 OF 1

File No.

70109879

Financial Code No.

23/SW/CTD/001

Drawn

RM

Checked

RM

Approved

AJ

Date

26/07/23

Date

26/07/23

Date

26/07/23

Scales

1:500

Drawing No.

70109879-WSP-HDG-ZZ-DR-CH-0001

P01