




Equipment List

Equipment ID	CELT Number	CV Number	Description	General Specification	Make	Model
P-201			Submersible Pump	230v 0.15kW. 11/4" - 1" 130l/min. 7m	JS-150SVA	
P-202	CELT316	CV184	Close Coupled Pump	5m3/hr. 21.4m. 1.5kW. 5.9/3.4A	Salvatore Robuschi	RSM 25-12B
P-202			End Suction Centrifugal Pump	230v. 0.75kW. 11/4" - 1". 110l/min. 31m		
P-203			Submersible Puddle Pump	230v. 0.3kW. 140l/min. 7m.	Flotec	Compac 150
PST-101	CELT037	CV183	Oil Water Separator		OTS	
SF-301	CELT321	CV191	Sand Filter (Glass Media Filter)	0.442m2. 21m3/hr. 50psi.	Spa and Pool Centre	34350
AGAC-402			Carbon Filter	6.5m3/hr. 2". 36 x 72. 2583mm H.	Euraqua	36 x72
OSD-601			205ltr Steel Screwed Top Drum			
WM-701			Water Meter	3 -5m3/hr. 1"	ARAD	M25
CP01			Control Panel			
BUND-701						
Trailer	CELT139	CV161			CLH	SFX10FB100112-C10012411

Legend

Note 1: All pipe work in 2" PVC or NBR hose

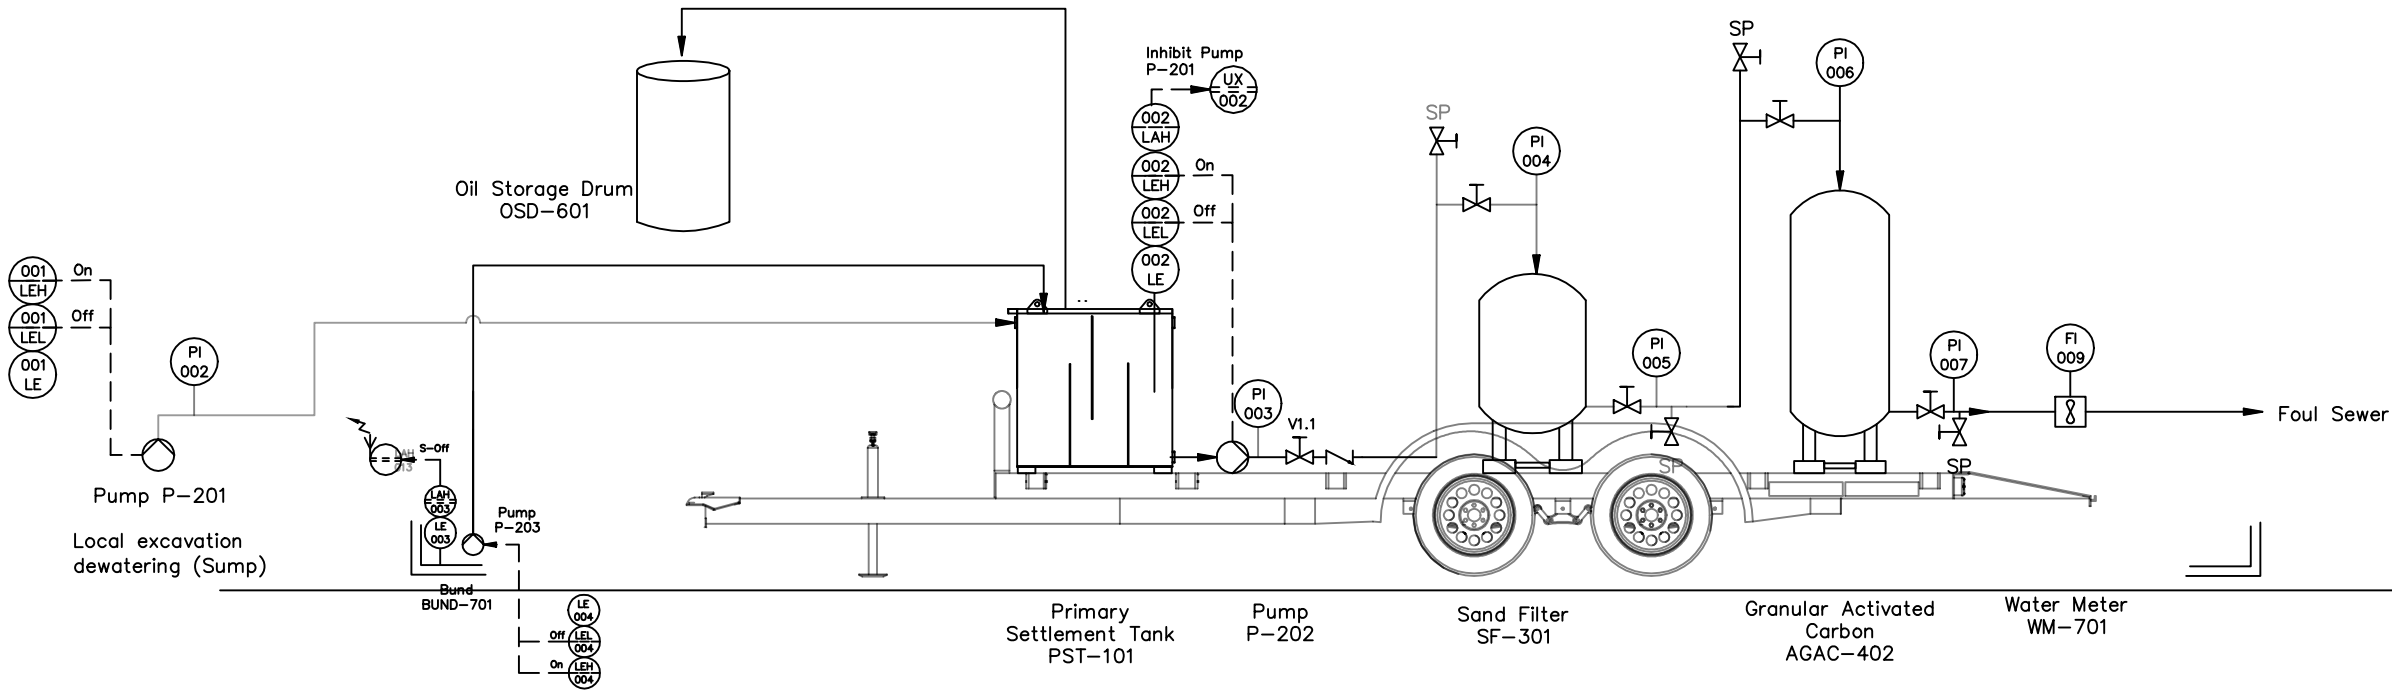

0	DRAFT	04/04/23
REV	COMMENT	DATE



Columbus House
Village Way
Cardiff
CF15 7NE
029 2036 8636

Centrix House
Crow Lane East
Newton Le Willows
WA12 9UY
01925 273222

enquiries@celtic-tech.co.uk
www.celtic-td.com

Client

Project
Quakers Yard

Title
Water Treatment System
Piping & Instrumentation
Diagram (Draft)

Drawn by	Checked	Date	Authorised	Date
AT	EL	11/21		
Original Scale	Date	Rev	Paper	
NTS	04/04/23	0	A3	

Drawing Number
D1871/5004/A1