
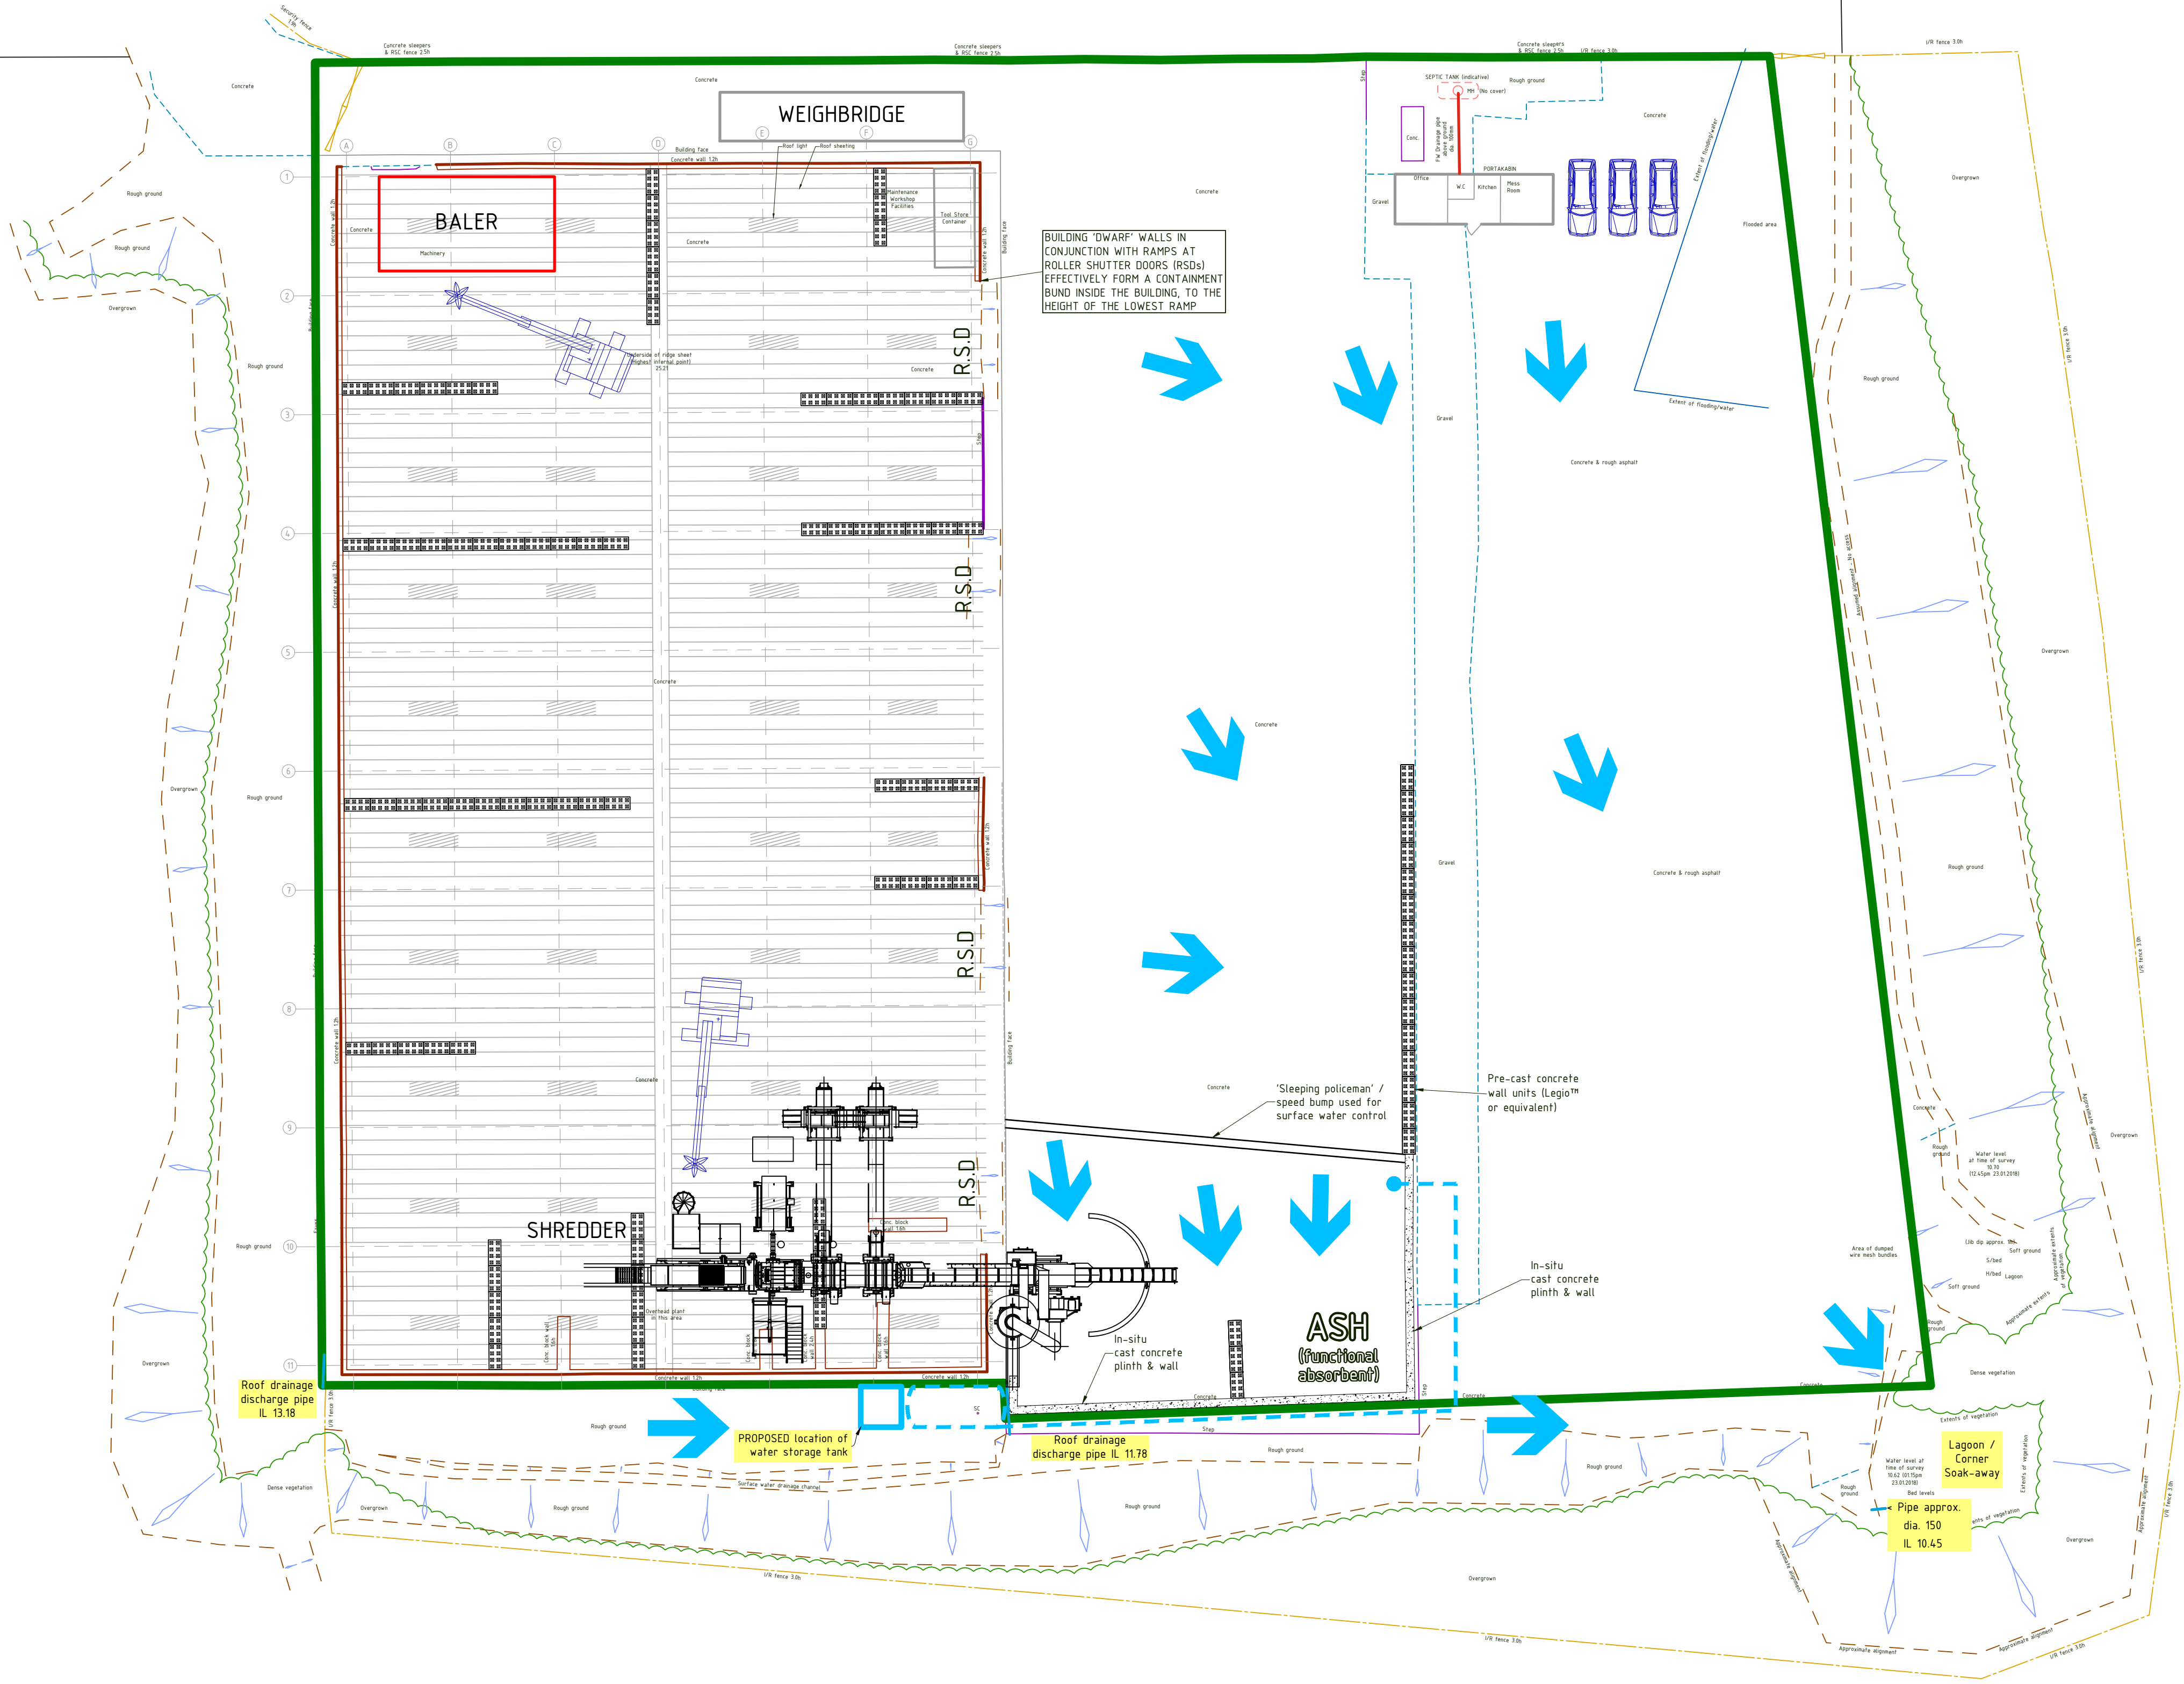


Scrap Yard

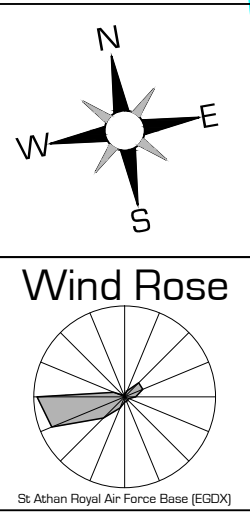


General Notes

NOTE

There are no surface water drains or drain-holes on site

KEY

- Permit boundary
- Flow direction of surface run-off
- Roof Water Connection (To Soak-aways)
- Foul Water Connection (Portakabin to Septic Tank)
- 'Sleeping Policeman' / Speed bump used for directing surface water flow
- Underground surface water collection tank & connecting pipework

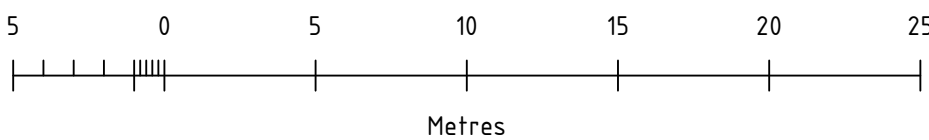

Reproduced from Ordnance Survey VectorMap District Raster data © Crown copyright 2018. All rights reserved. Licence number 0100031673

A	Outside storage bays removed	June 2018
No.	Revision/Issue	Date



CDUlike
innovation. by design.



Drawing Title, Project Name and Address
FIRE PROTECTION PLAN - DRAINAGE
Morris & Co (Handlers) Ltd
Top Shed, Neath Abbey Wharf
Skewen,
Neath, SA10 6BL

Project	MORRIS & Co	Drg No
Date	February 2018	09
Scale	1:250 @ A1	REV A