


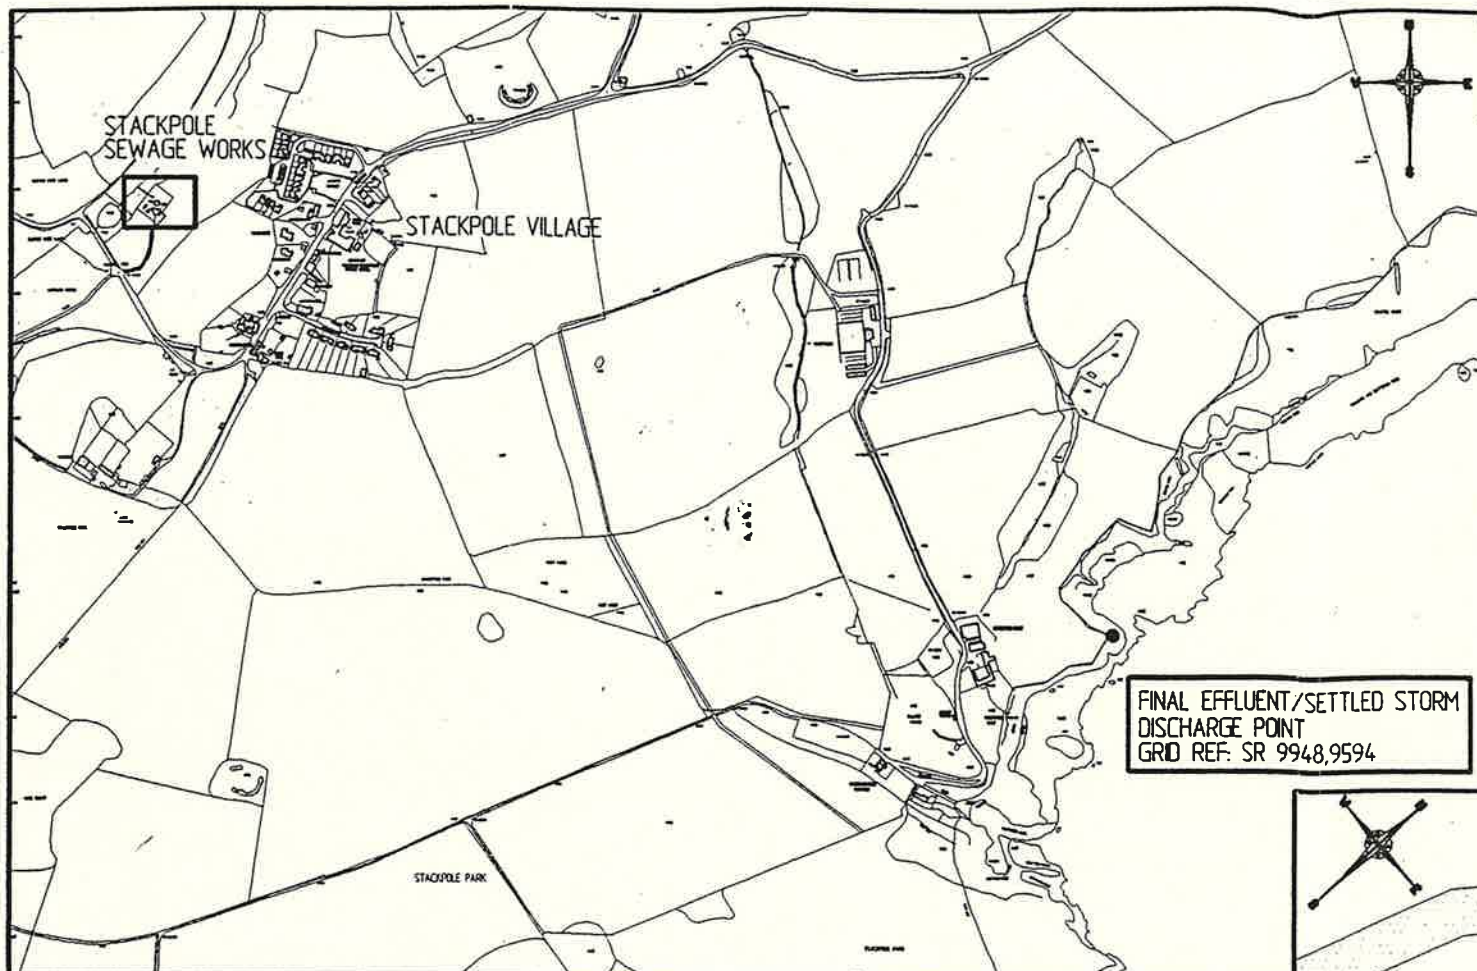


DISCHARGE LOCATION PLAN

SCALE 1:100,000


ENVIRONMENT AGENCY WALES	
PLAN N° BP0217701	

ANNEX 3

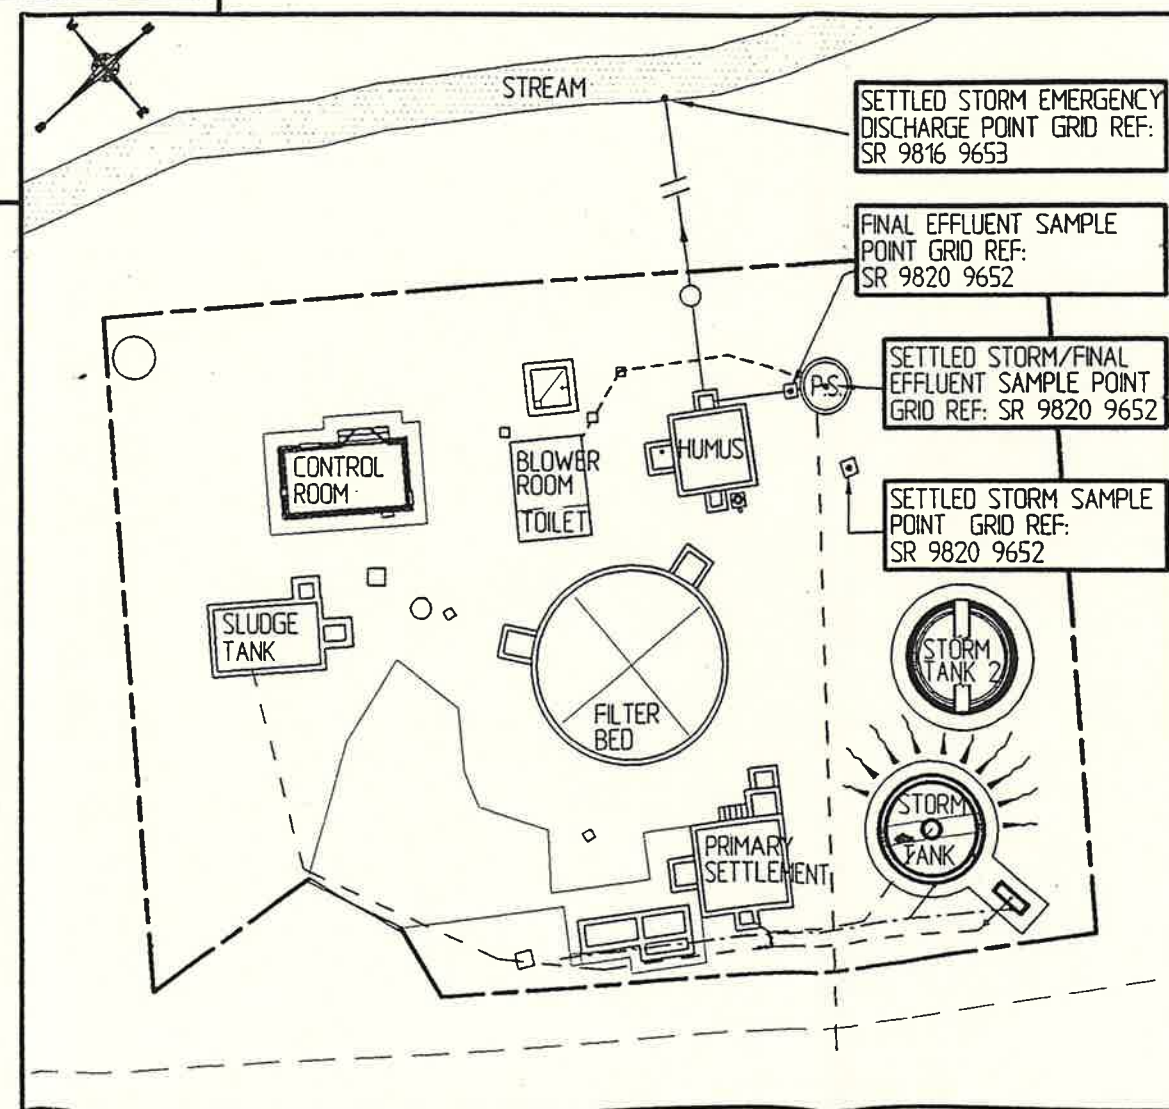

STACKPOLE S.T.W.

SCALE 1:500

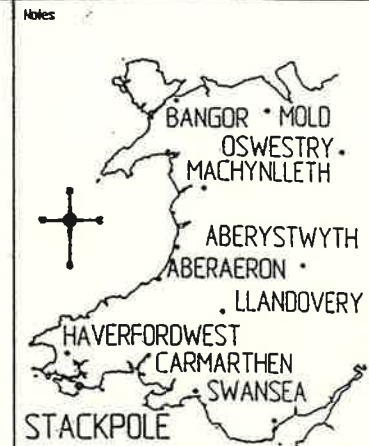

LOCATION PLAN

A	DISCHARGE CONSENT CONSULT	P	BHG	AJM 29.10.99
Issue	Description	Auth	Clad	Appl. Date
Client				
DWR CYMRU CYFNGEDIG SOUTH WESTERN DIVISION				
Project				
STACKPOLE S.T.W.				
Title				
LOCATION AND SITE PLAN FOR DISCHARGE CONSENT				
Scale A3		Datum		
AS SHOWN		LOCAL		
Hyder		HYDER CONSULTING Physicist Member Sewerage SA7 9HW Tel: +44 (0)1792 771108 Fax: +44 (0)1792 701908		
Project Code		Drawing No.		Issue
NE61559		001		A