

NOTES:

1. NO DIMENSIONS TO BE SCALED FROM THIS DRAWING - USE FIGURED DIMENSIONS ONLY.
2. ALL DIMENSIONS ARE SHOWN IN MILLIMETRES (mm), UNLESS STATED OTHERWISE.

KEY:

- MAIN PROCESS - CONTINUAL FLOWS
- SECONDARY PROCESS
- SLUDGE TREATMENT PROCESS
- ENERGY RECOVERY PROCESS
- SERVICE WATER FLOWS
- EXPORT
- STORM OVERFLOW
- MAGFLOW METER
- SAMPLING POINTS
- EMISSIONS TO ATMOSPHERE
- SURFACE WATER FLOW
- STC AREA

P01	04.08.25	SK	WORK IN PROGRESS	MO	TM	13.08.25
Rev.	Date.	BIM.	Description.	Chk.	App.	Iss Date.



Project Name: AFAN WwTW - IED COMPLIANCE SOLUTION


Drawing Title: PROCESS FLOW DIAGRAM

Suitability: FOR INFORMATION Suitability Code: S2

Technician: SK	Originator: SN	Date: 04.08.25
Internal Project Number: DC25J812	Scale: N/A @A1	Rev: P01

Drawing Number: B17497-123532-22-ZZ-DI-PA-PR1007

MMB
MOTT MACDONALD
BENTLEY

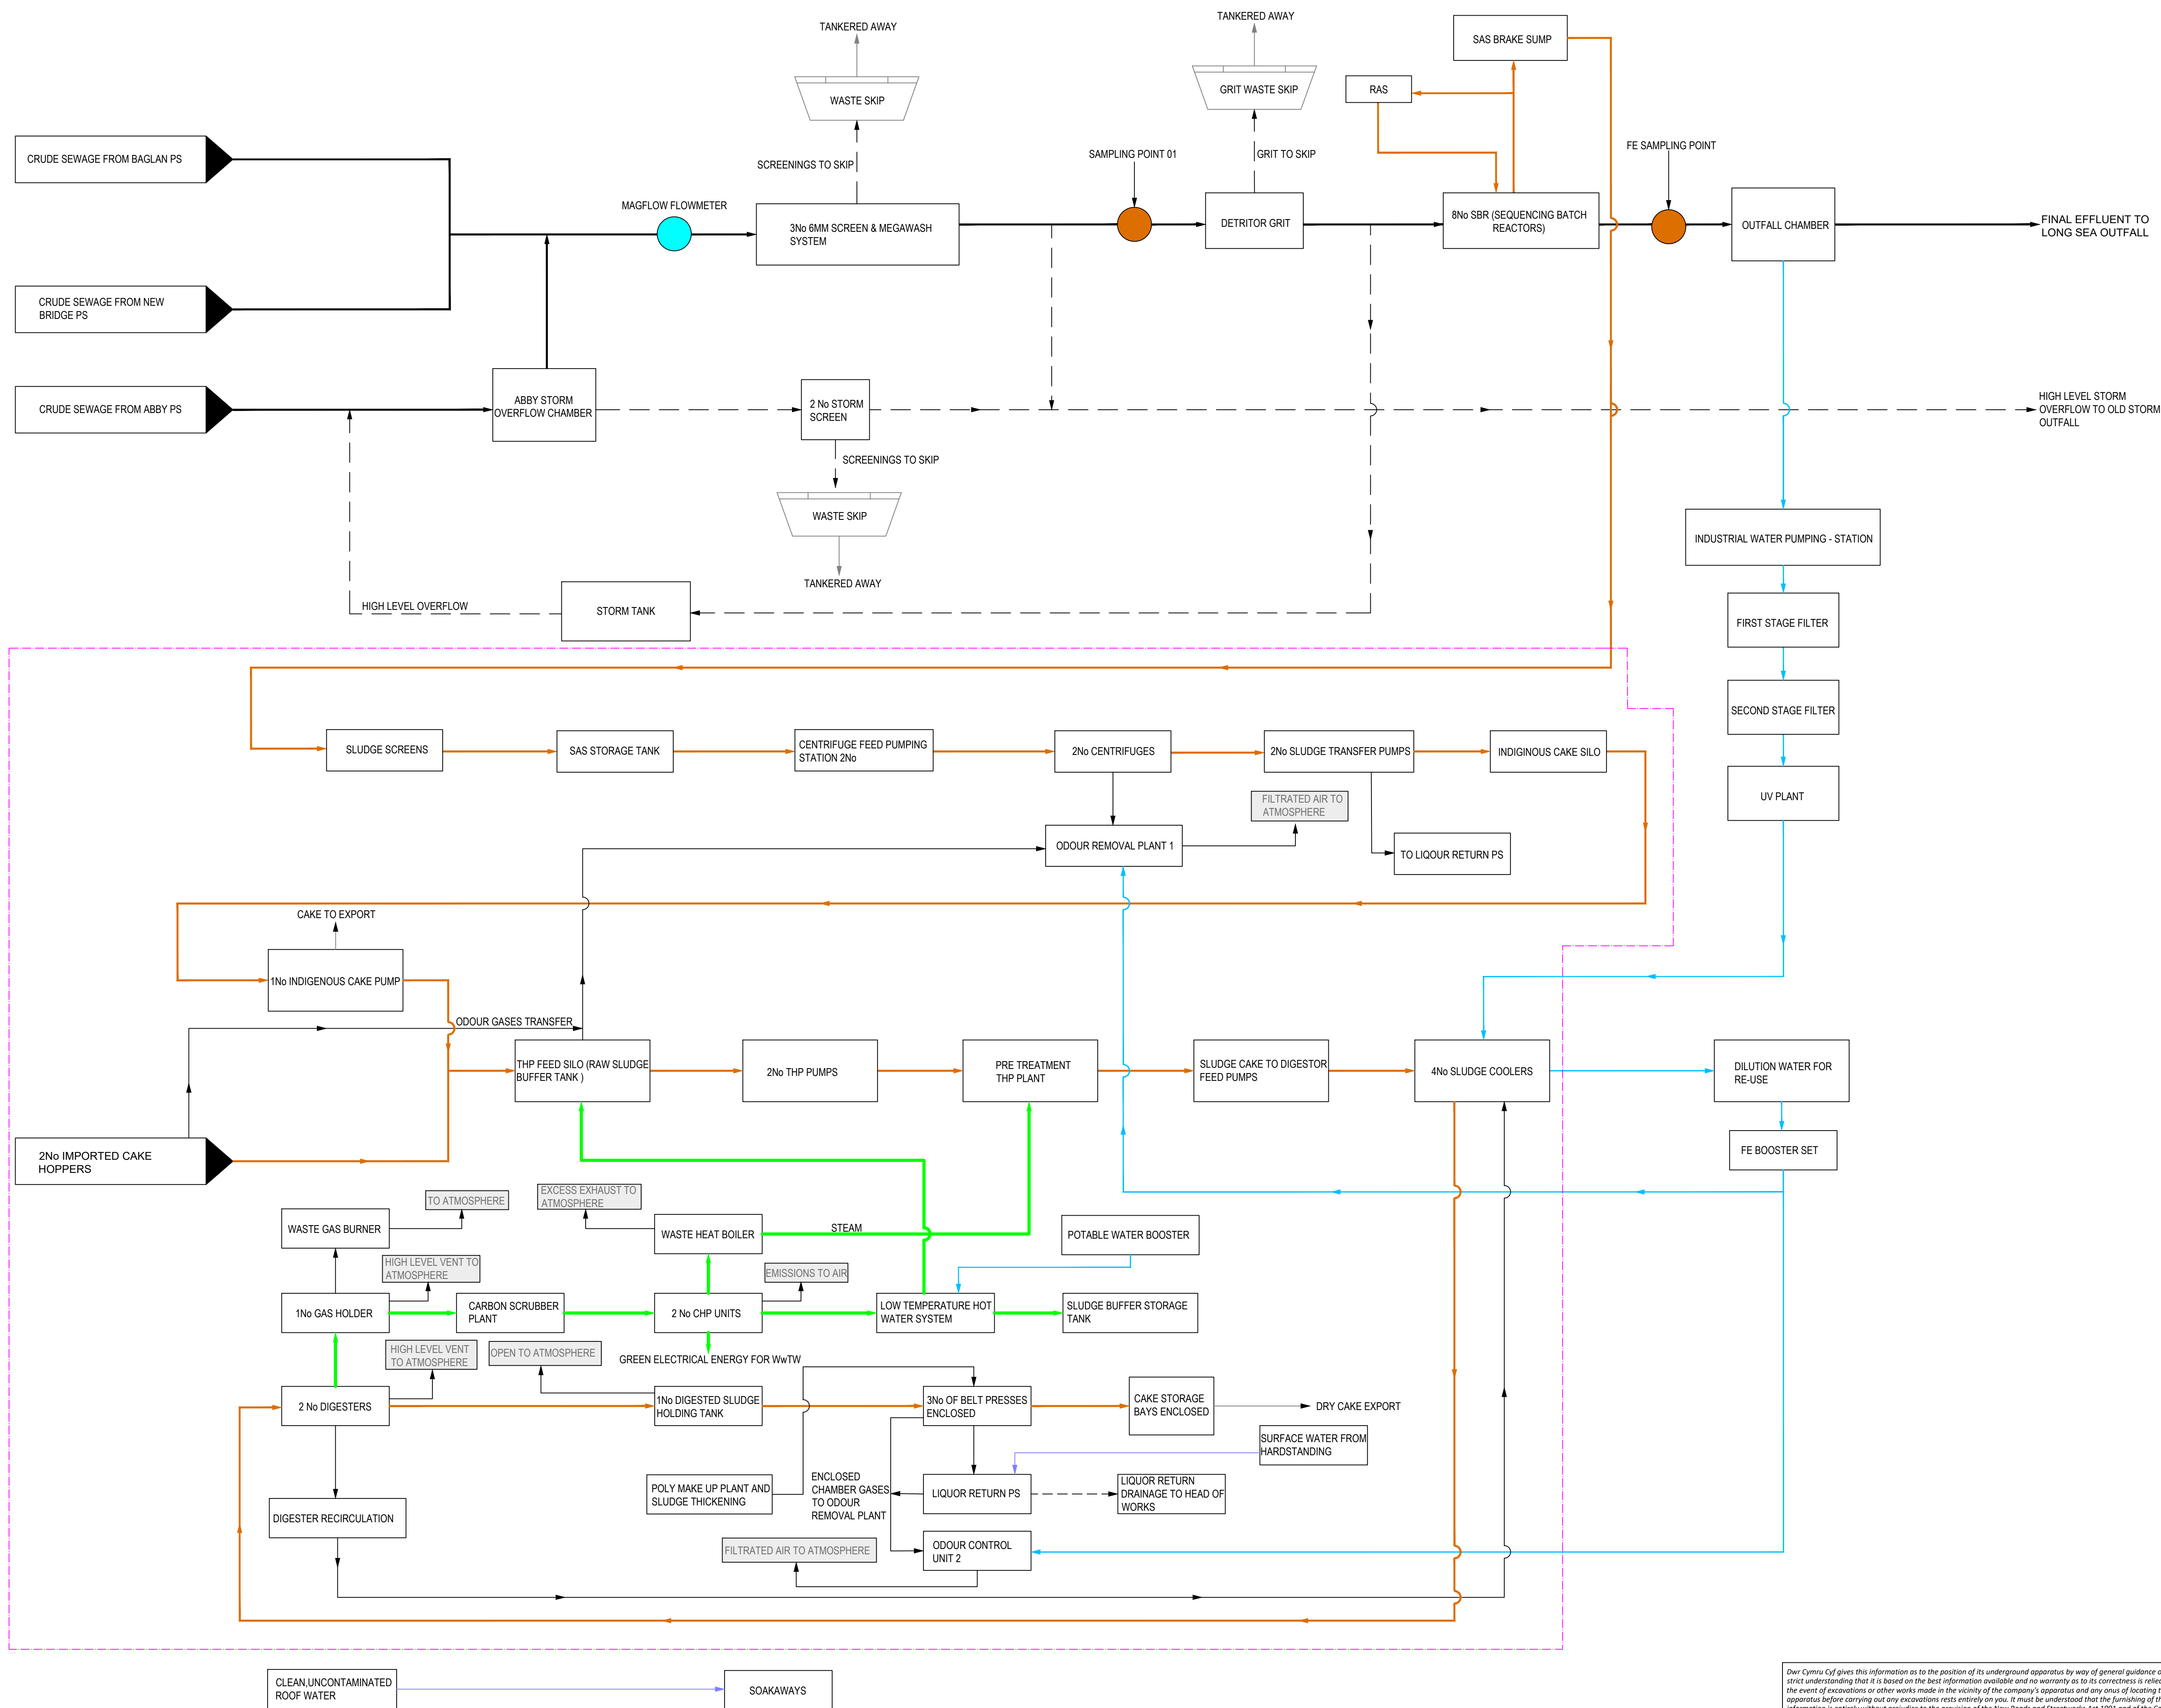

Dwr Cymru Cyf gives this information as to the position of its underground apparatus by way of general guidance only on the strict understanding that it is based on the best information available and no warranty as to its correctness is relied upon in the event of excavations or other works made in the vicinity of the company's apparatus and any anus of locating the apparatus before carrying out any excavations rests entirely on you. It must be understood that the furnishing of the information is entirely without prejudice to the provision of the New Roads and Streetworks Act 1991 and of the Company's right to be compensated for any damage to its apparatus.

Dwr Cymru Cyf has no duty to identify private apparatus and the information as to the position of the private apparatus is given by way of general guidance only on the strict understanding that it is based on the best information available and no warranty as to its correctness is relied upon. Not all private apparatus is identified but their presence should be anticipated.