

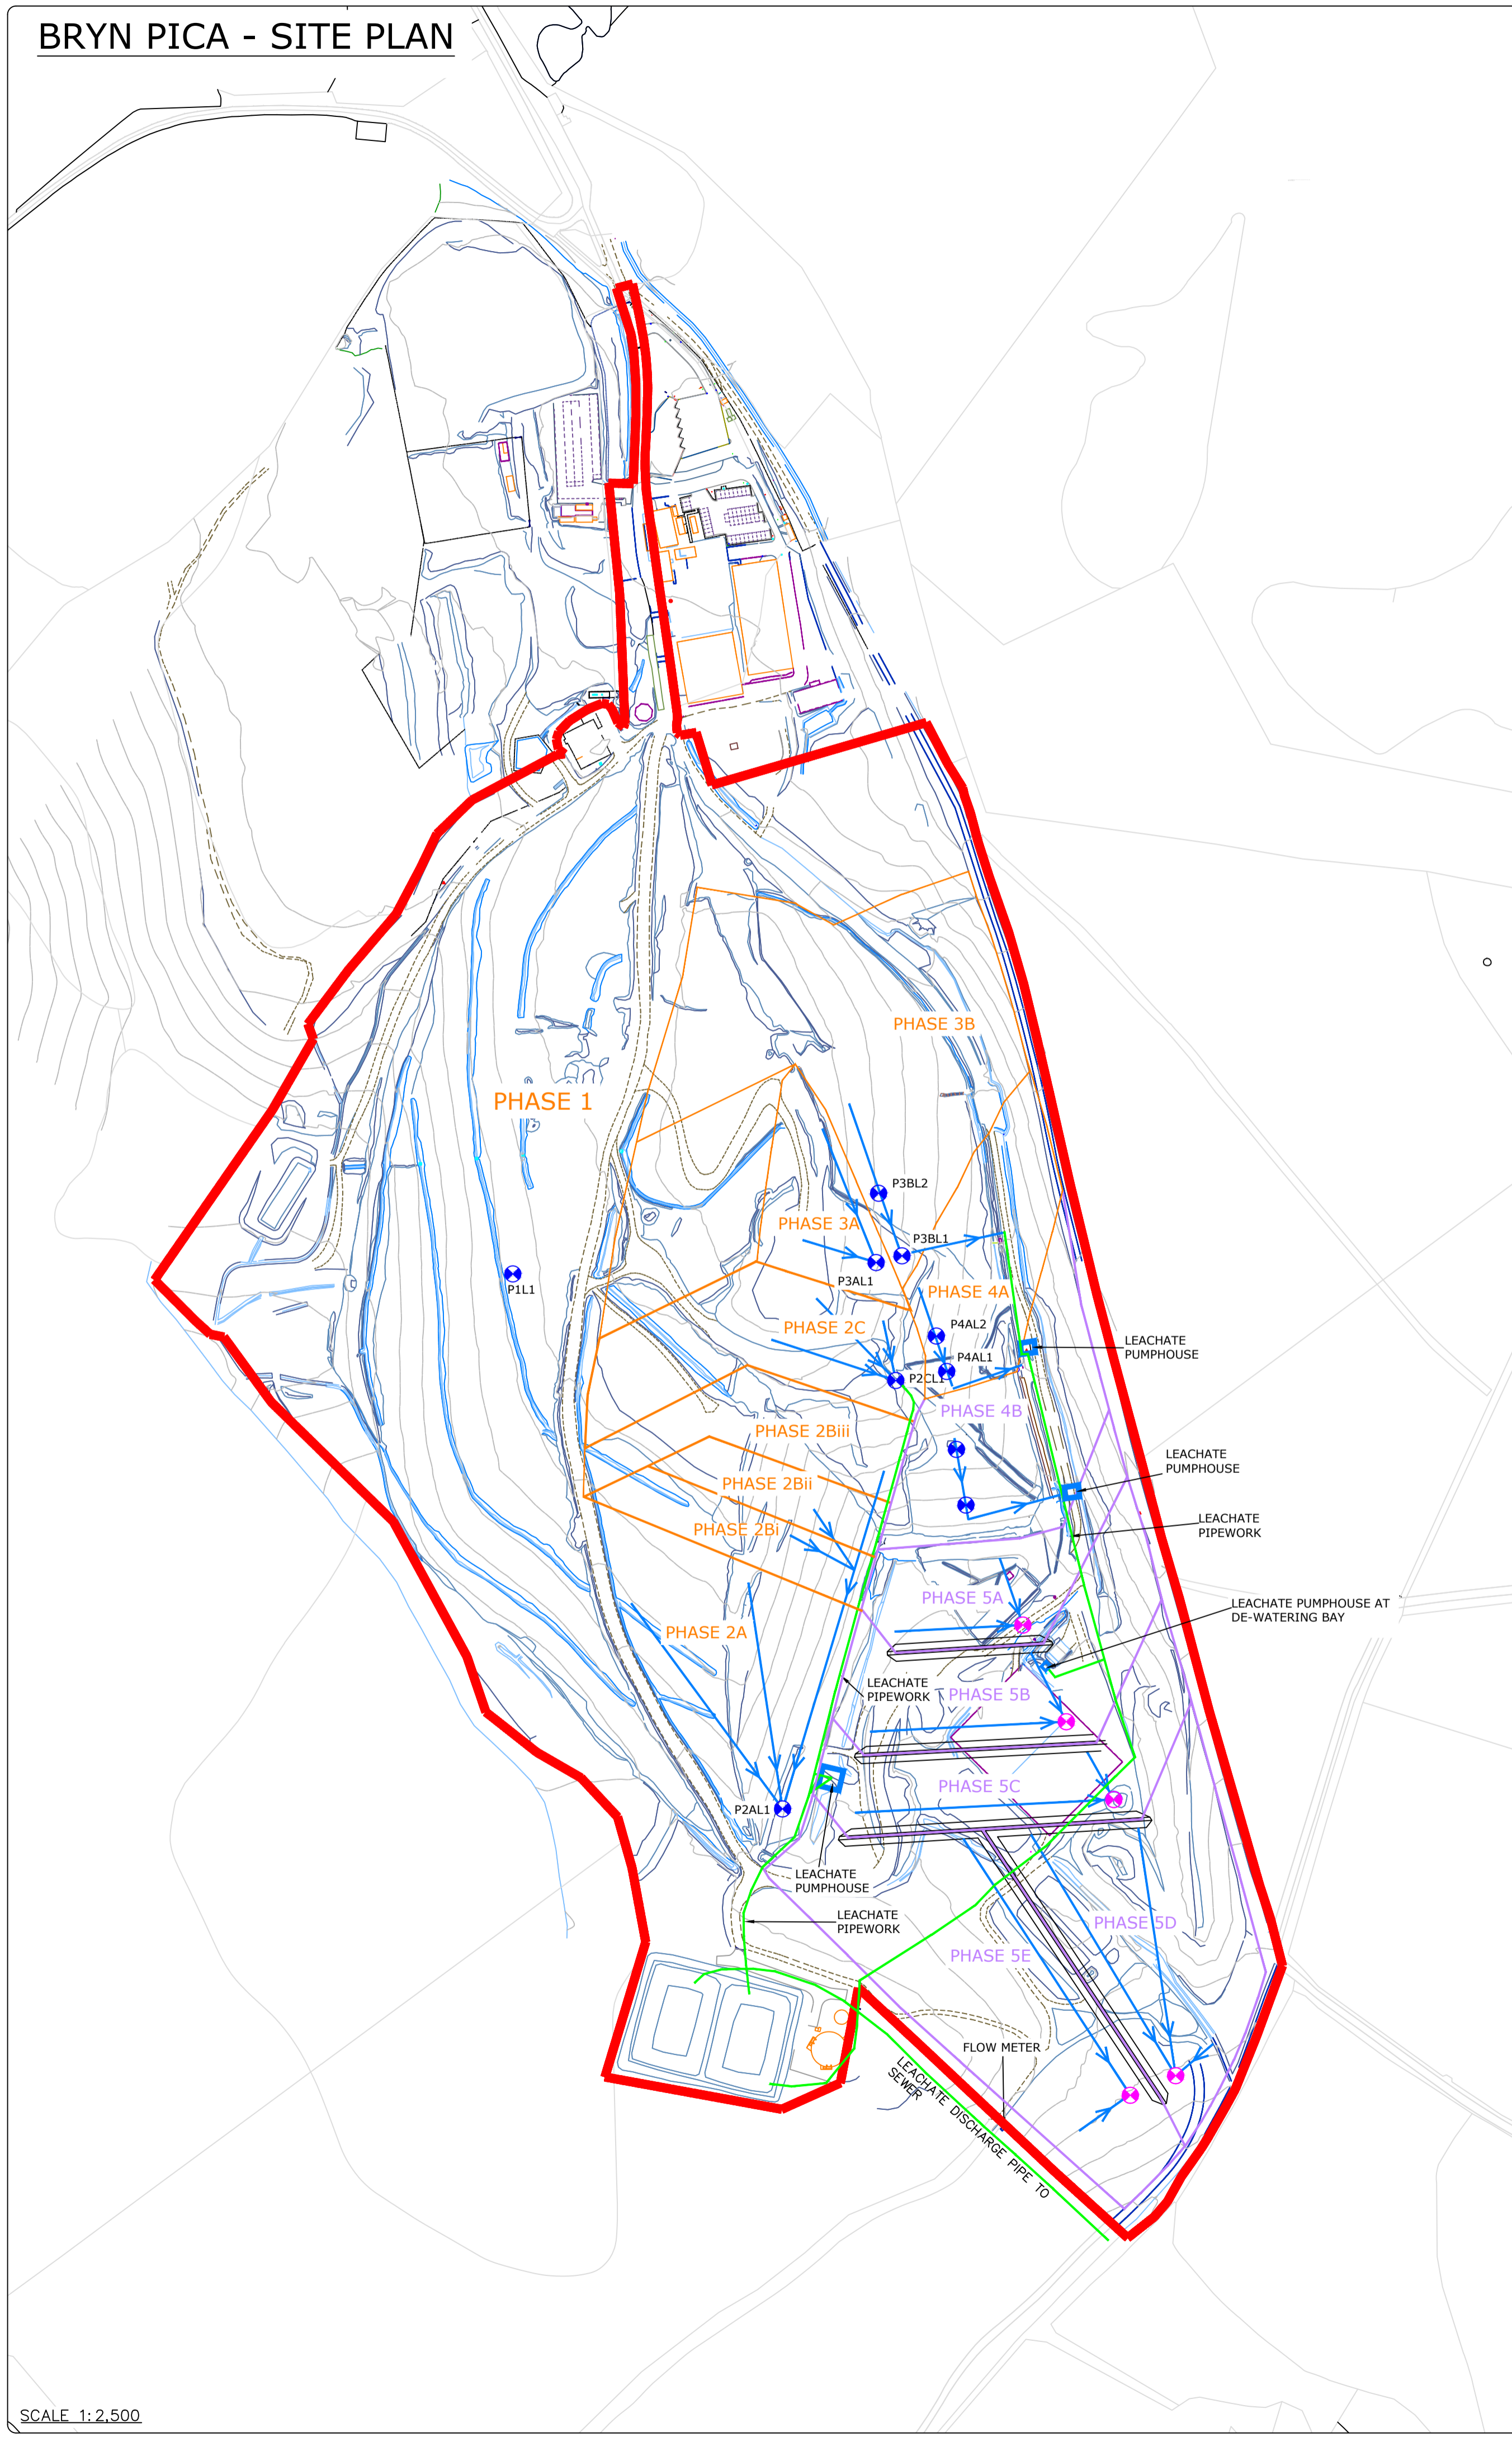
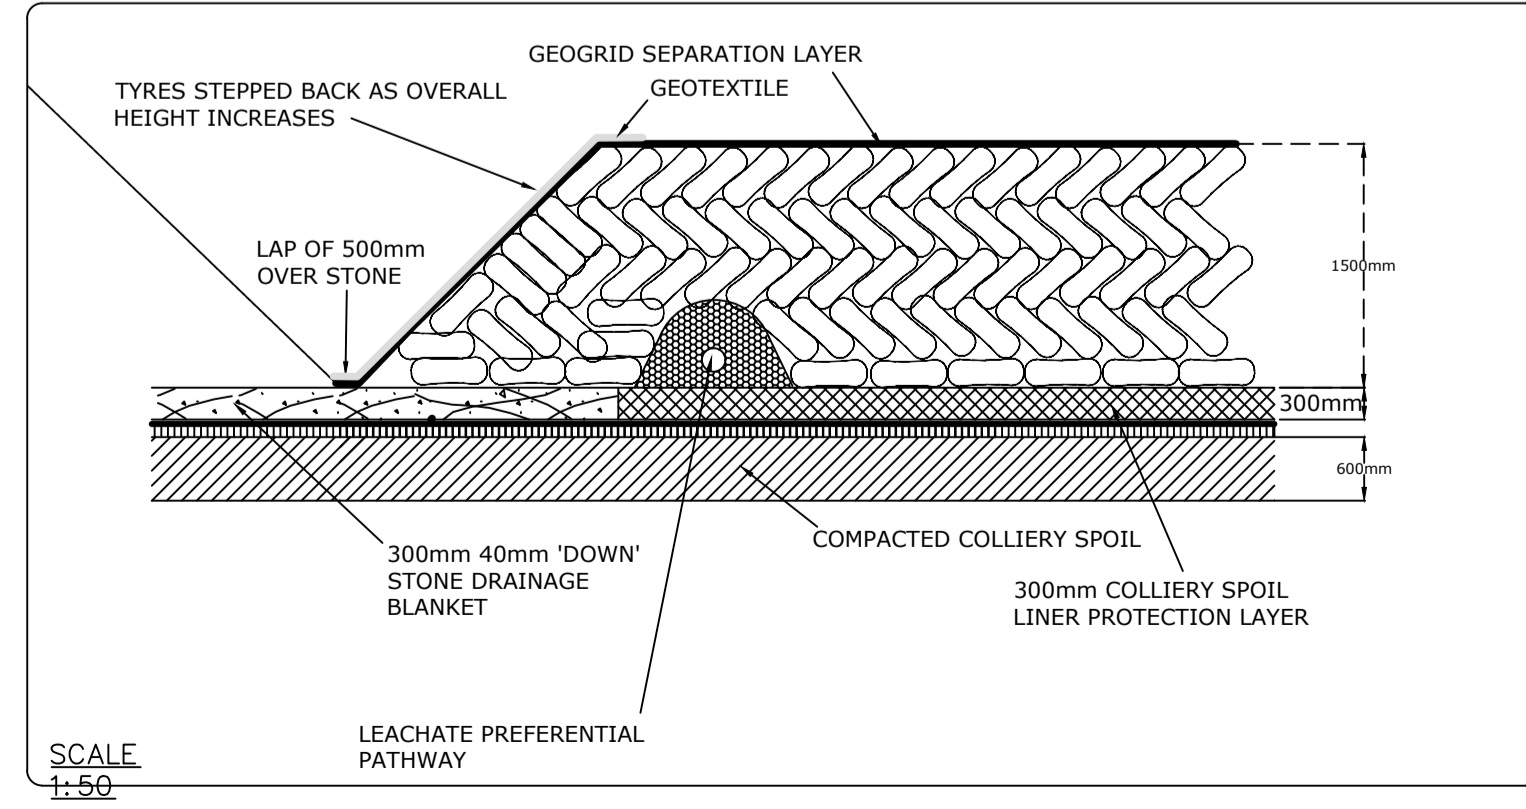
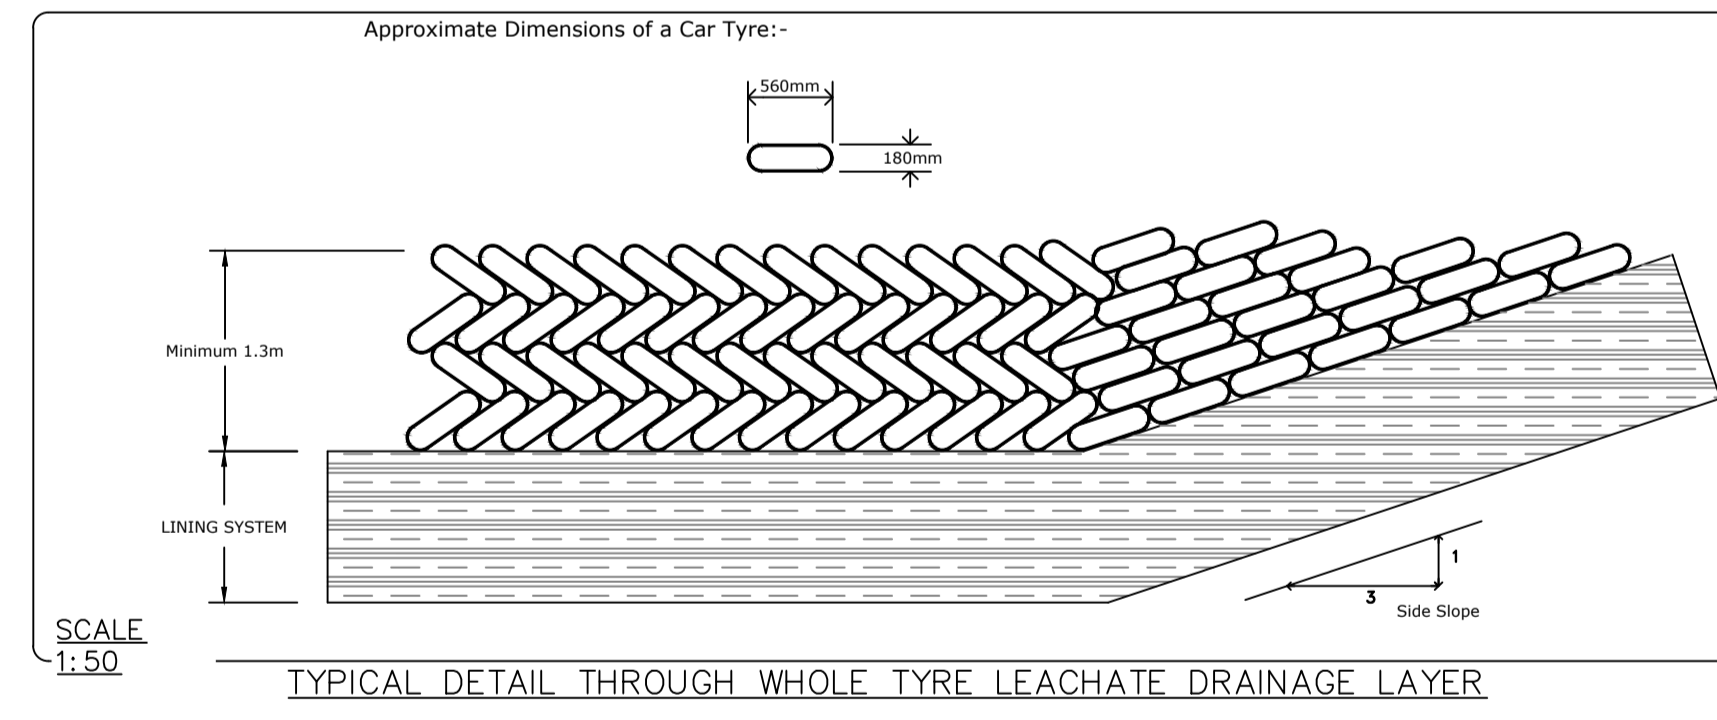
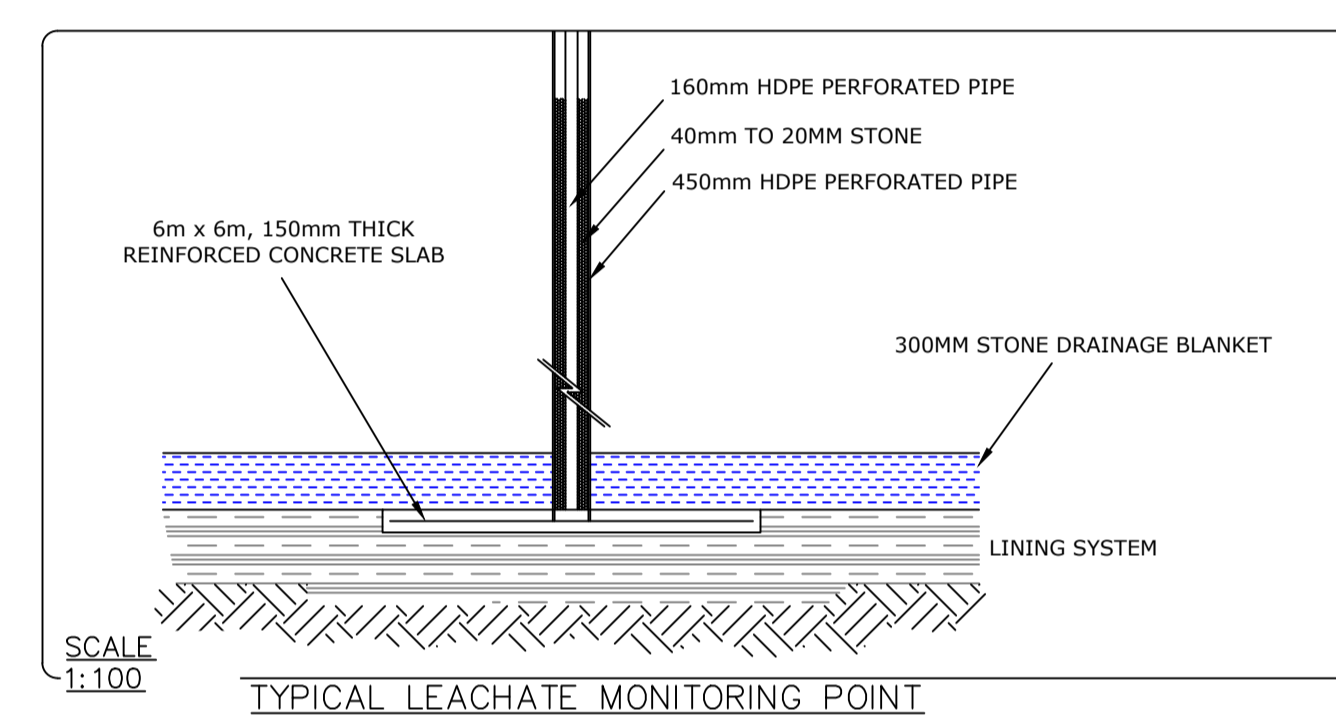


BRYN PICA - SITE PLAN

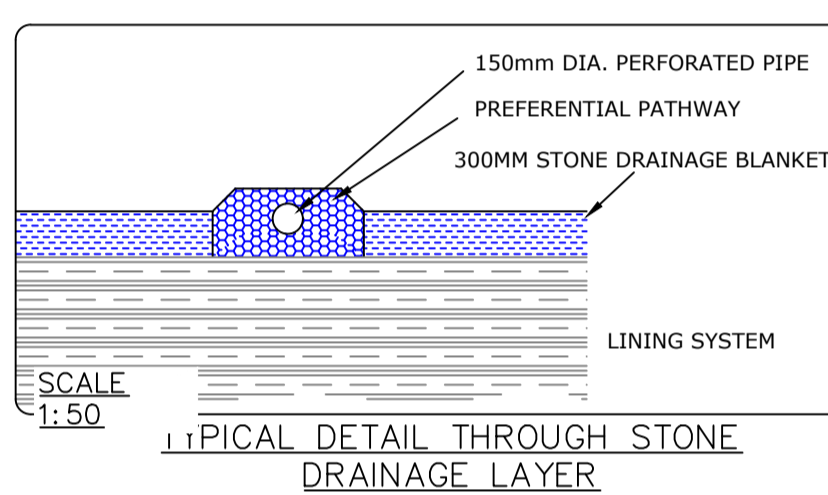

SCALE 1:2,500

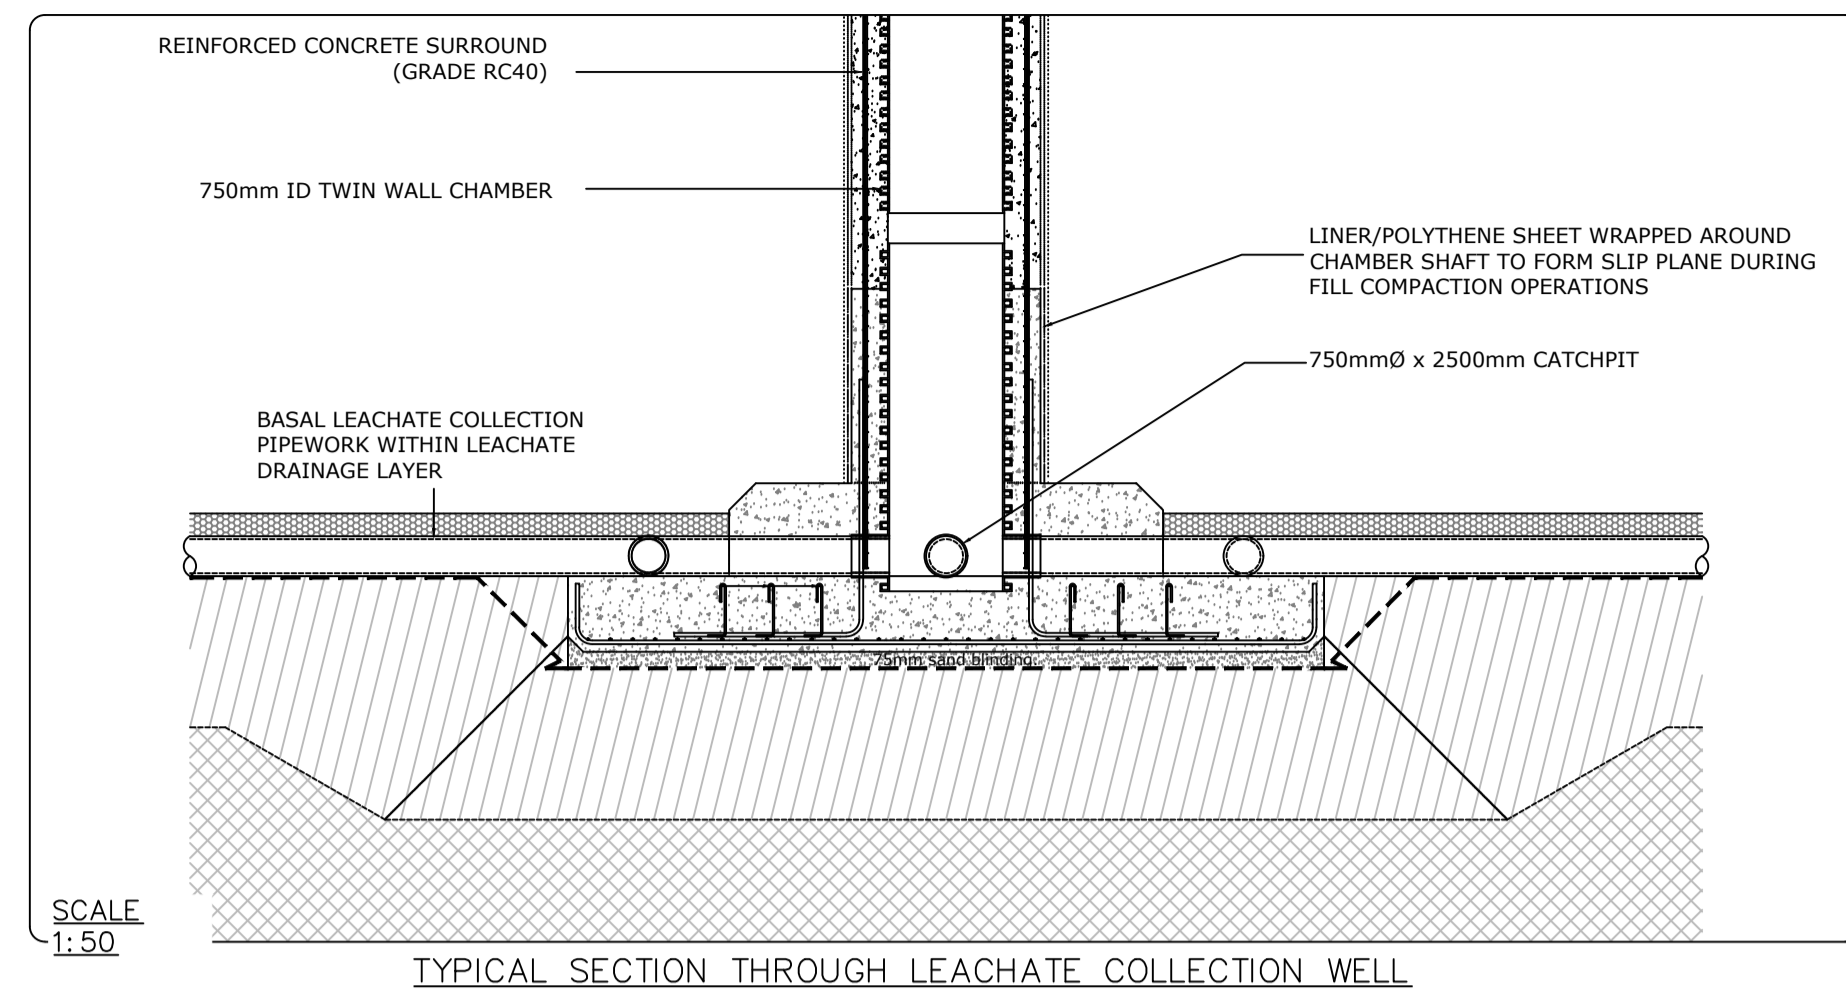

- Notes:
- All levels to meters A.O.D.
 - Do not scale from drawing.
- Legend
- INSTALLATION BOUNDARY
 - PHASE BOUNDARIES (EXISTING)
 - PHASE BOUNDARIES (PROPOSED)
 - LEACHATE CARRIER PIPEWORK
 - LEACHATE COLLECTION PIPEWORK
 - EXISTING LEACHATE MONITORING POINTS
 - FUTURE PROPOSED LEACHATE COLLECTION CHAMBERS

Client: AMGEN Cymru Ltd

Job Title: Bryn Pica Waste Management Facility Annual Report 2019

Drawing Title: Leachate Management

Drawing No.:	AC2020/ENV/01/002	Revision:	—
Scale:	As Shown	Sheet size:	A1

Rev.	Description	Date
—	—	—

Drawn by:	APW	Checked by:	APW
Date:	30 01 2020	Date:	30 01 2020

AMGEN Cymru Ltd.
Bryn Pica
Llywdcoed
Aberdare
CF44 0BX.
Tel: 01685 870770