


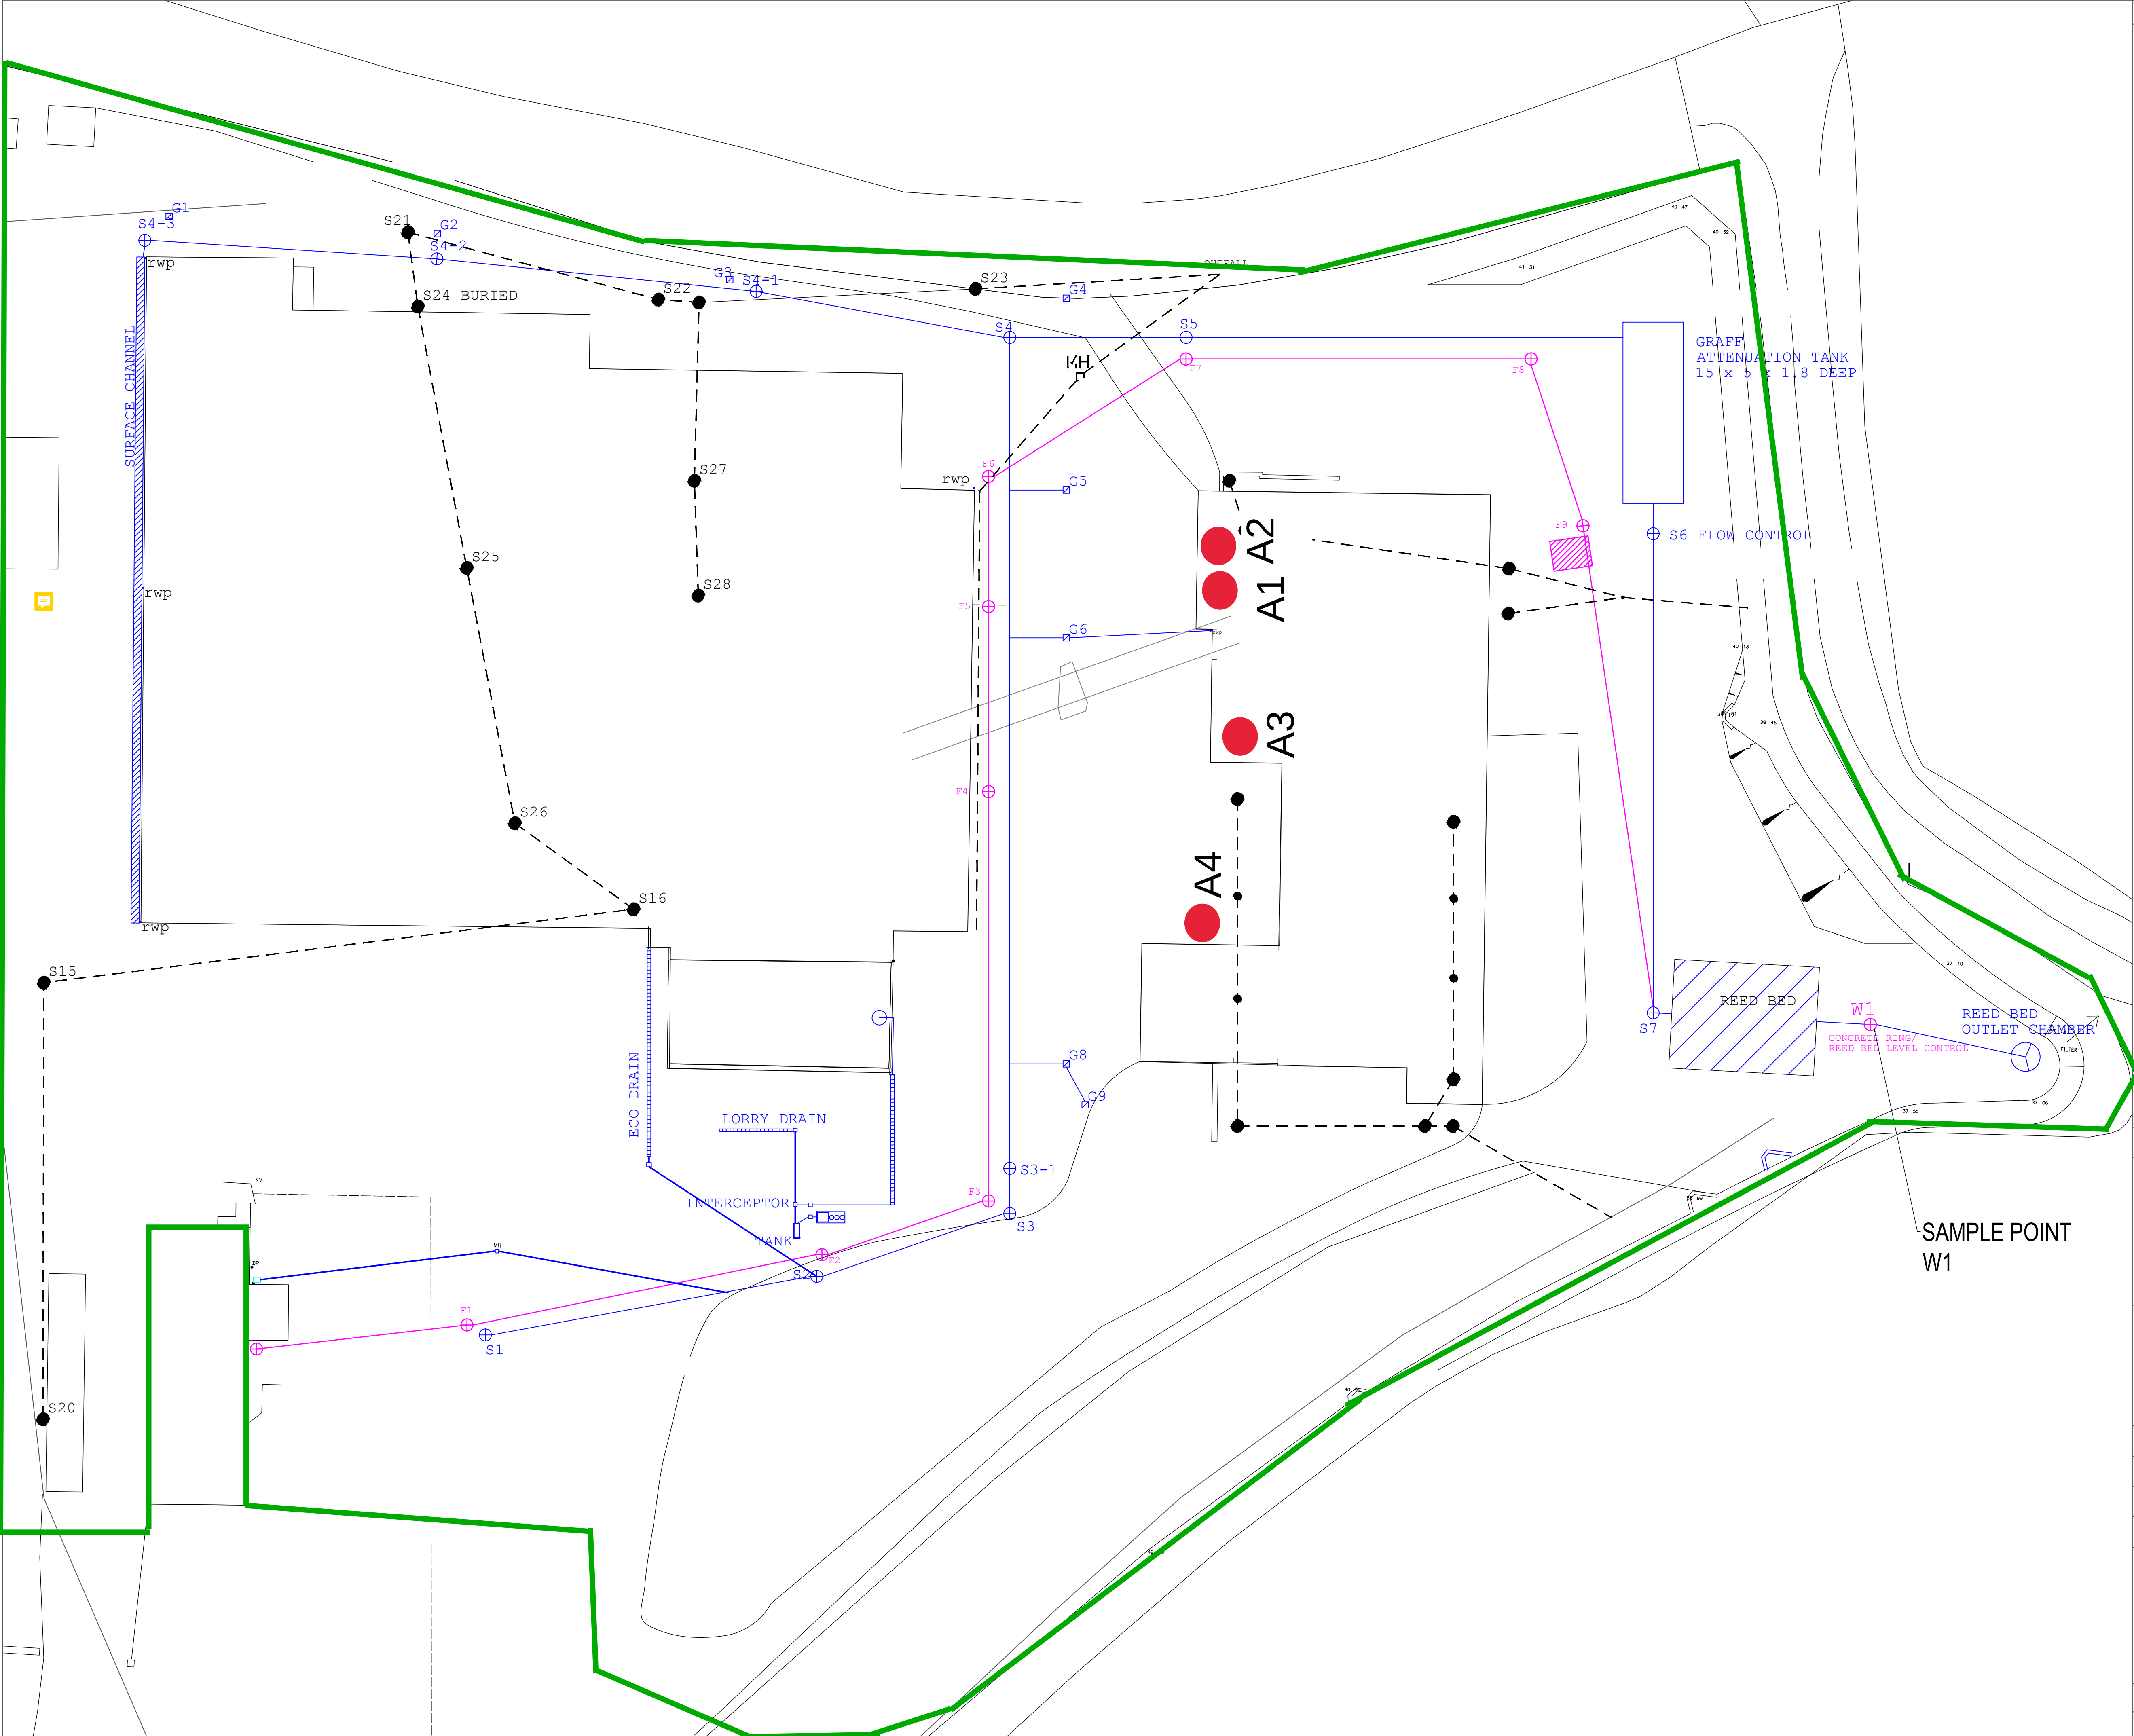

Notes:	A1
As built drawings based on the information provided by Burke Construction.	
--- DECOMMISSIONED DRAINAGE --- NEW STORM DRAINAGE --- NEW FOUL DRAINAGE	
Issued for Comment	
Job: Wynnstay Drainage Design	
Title: Drainage Layout As Built	
Date: January 2019	
Scale: 1:250@A1	
Drawn by: AJD	
Checked by: AD	
ExCAL House, Capel Hendre Ind. Est., Ammanford, Carmarthenshire, SA18 3SJ Tel: 01269 831606 Fax: 01269 841867 Website: www.excaluk.com E-mail: info@excaluk.com	
Drawing No: 129-01-14.D14	
Revision No: C	Date: 12.01.2021