




BRYN PICA - SITE PLAN

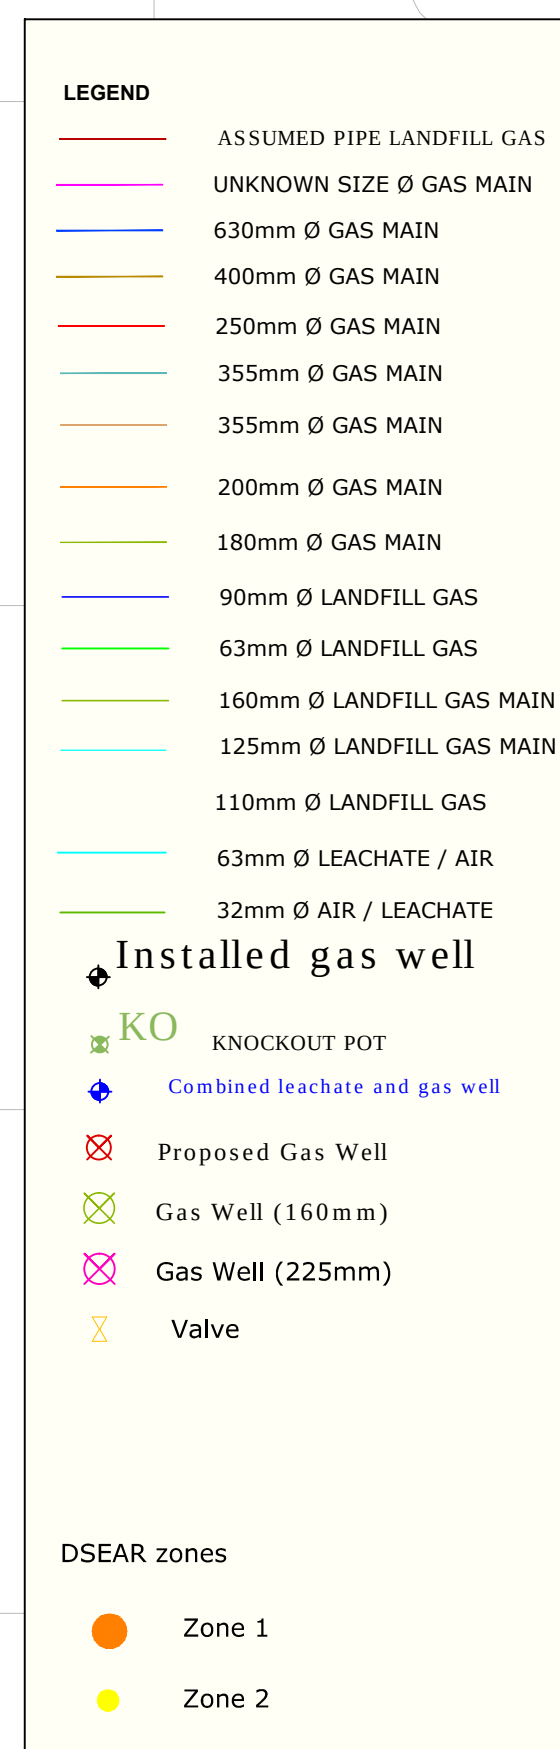


SCALE 1:1,500

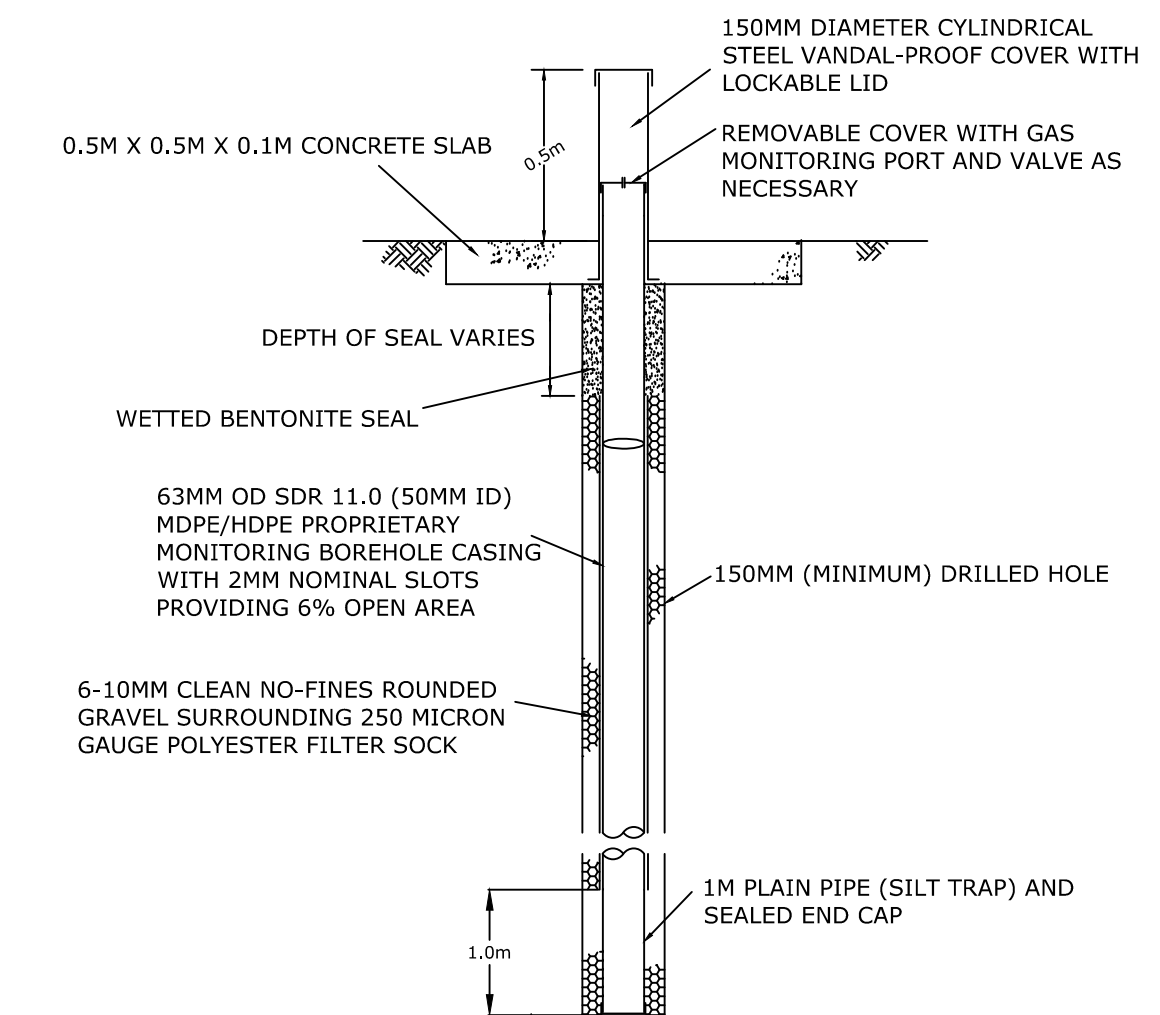

GAS WELL CONSTRUCTION DETAIL

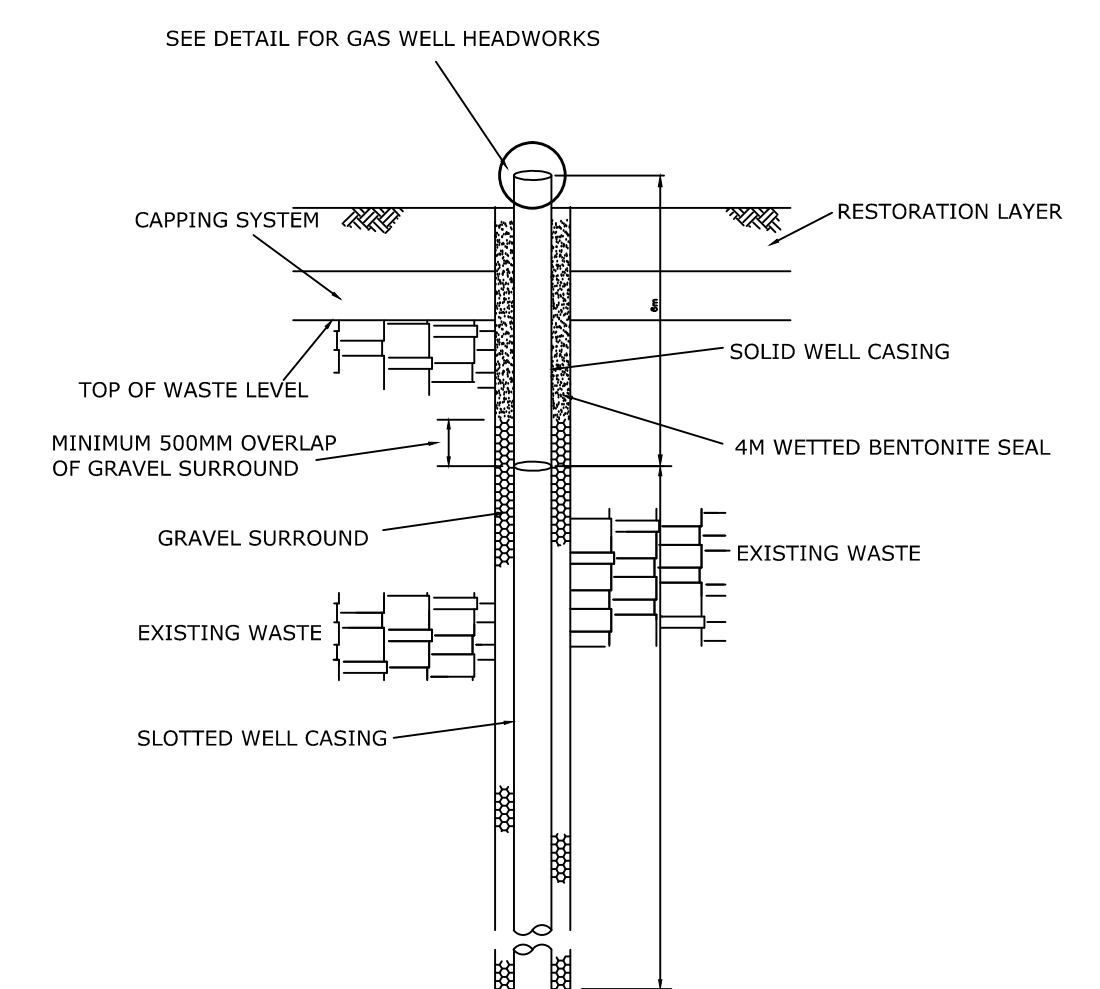

TYPICAL GAS WELL HEADWORKS

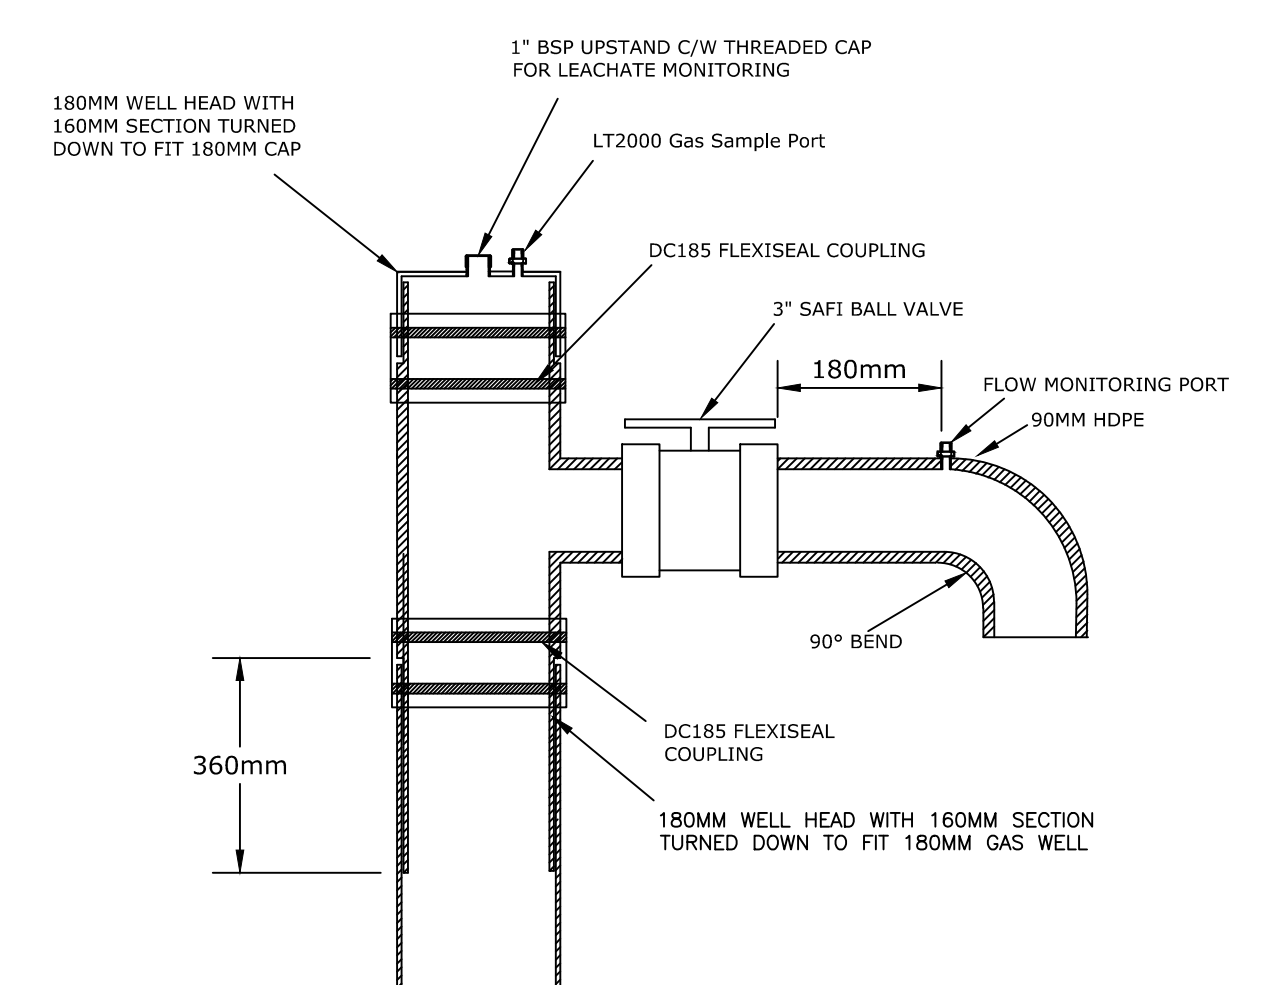

 AMGEN CYMRU BRYN PICA LLWYDCOE ABERDARE CF44 0BX TEL: 01685 870770 FAX: 01685 874684	PROJECT TITLE BRYN PICA WASTE MANAGEMENT FACILITY ANNUAL REPORT 2014					
	DRAWING TITLE LANDFILL GAS MANAGEMENT SYSTEM					
	DRAWN BY APW	DATE 16.02.2015	CHECKED BY LF	16.02.2015		
	SCALE AS SHOWN	SHEET SIZE A1	DRAWING No: AC2015/ENV/03/003		REVISION 0	
	NOTES					
	REV	DESCRIPTION			DATE	BY