


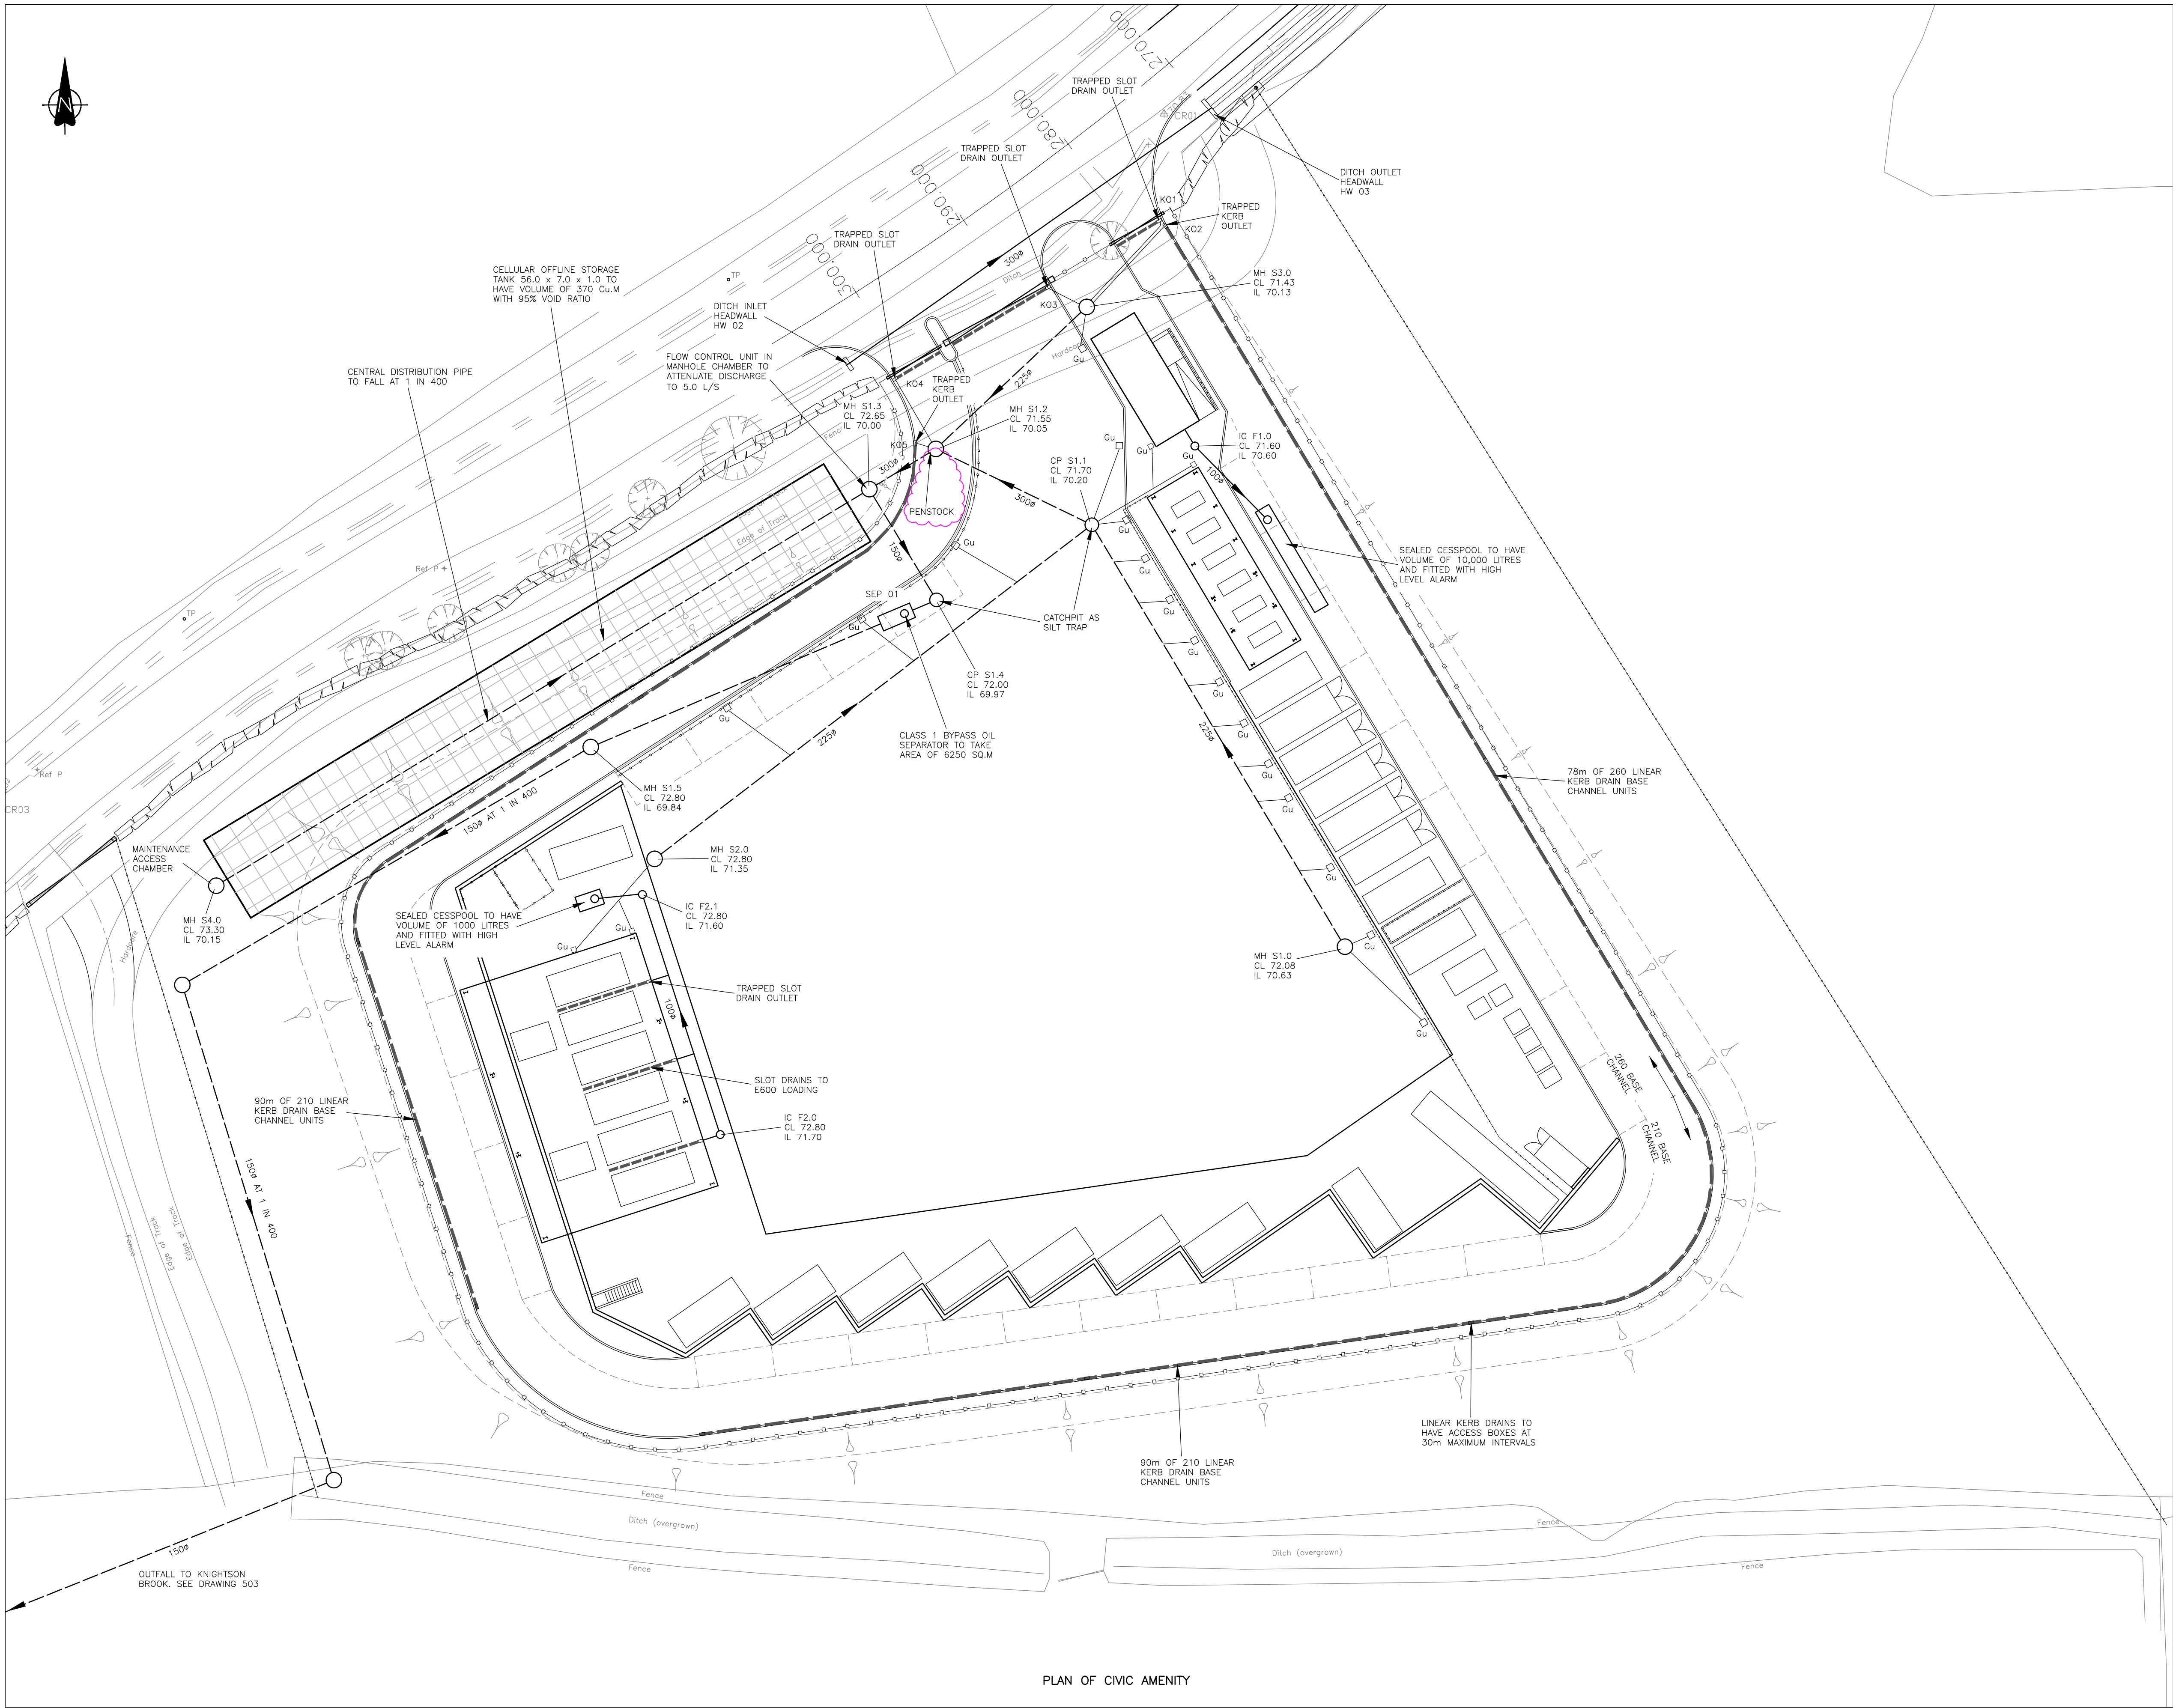

PLAN OF CIVIC AMENITY

- NOTES
1. LINEAR KERB DRAINS TO BE MARSHALLS MINI BEANY WITH 210 AND 260 BASE CHANNEL UNITS – OR SIMILAR APPROVED
 2. SLOT DRAINS TO BE MARSHALLS MAX E CHANNELS WITH 205 BASE CHANNEL UNITS – OR SIMILAR APPROVED
 3. SURFACE WATER STORAGE TANK TO BE AS SUSTAINABLE DRAINAGE SYSTEMS LTD – OR SIMILAR APPROVED
 4. GULLY POTS TO BE 450ø 750 DEEP WITH TRAPPED 150ø OUTLETS
 5. GULLY CONNECTIONS AND LINEAR DRAINAGE OUTLET CONNECTIONS TO BE 150ø WITH 150 CONCRETE BED AND SURROUND
 6. MANHOLE COVERS AND GULLY GRATINGS TO BE CLASS D400
 7. FOUL SEWAGE FROM TOILET BLOCK TO BE CONTAINED IN SEALED CESSPOOL HAVING VOLUME OF 10,000 LITRES AS SPEL SERIES 200 GRP TANKSTOR WITH HIGH LEVEL ALARM – OR SIMILAR APPROVED. VOLUME BASED ON BRITISH WATER FLOWS AND LOADS 3, INDUSTRIAL OFFICE / FACTORY WITHOUT CANTEN USING 50 LITRES/PERSON PER DAY AND 4 No OPERATIVES ON SITE. TANK TO BE EMPTIED AT 50 DAY INTERVALS
 8. FOUL LIQUOR FROM COMPACTOR BUILDING TO BE CONTAINED IN SEALED CESSPOOL HAVING VOLUME OF 1000 LITRES AS SPEL SERIES 200 GRP TANKSTOR WITH HIGH LEVEL ALARM – OR SIMILAR APPROVED.
 9. SURFACE WATER STORAGE TANK AND CESSPOOL TO BE CHECKED FOR FLOTATION
 10. OIL SEPARATOR TO BE CLASS 1 BYPASS TYPE TAKING AREA OF 6250 SQ.M AS CONDER CNSB15/21 – OR SIMILAR APPROVED
 11. PENSTOCK TO BE FITTED TO OUTLET PIPE OF MH S1.2. PENSTOCK TO BE 300ø, ON SEAT, FLUSH INVERT, WALL MOUNTED WITH NON RISING SPINDLE AS HAM BAKER CAST IRON SERIES 60. CONCRETE MOUNTING WALL TO BE CAST INSIDE CHAMBER.

- PROPOSED LINEAR KERB DRAIN
- PROPOSED SLOT DRAIN
- PROPOSED SURFACE WATER SEWER
- PROPOSED FOUL SEWER
- PROPOSED GULLY AND CONNECTION

EXTRACT FROM ORDNANCE SURVEY.
REPRODUCED FROM THE ORDNANCE SURVEY MAPPING WITH THE PERMISSION OF THE CONTROLLER OF HER MAJESTY'S STATIONERY OFFICE.
© CROWN COPYRIGHT.
UNAUTHORISED REPRODUCTION INFRINGES CROWN COPYRIGHT AND MAY LEAD TO PROSECUTION OR CIVIL PROCEEDINGS.
PEMBROKESHIRE C.C. LOCAL AUTHORITY LICENCE No LA 100023344

HEALTH, SAFETY & ENVIRONMENTAL INFORMATION

NOTE:
IT IS ASSUMED THAT THE WORKS WILL BE UNDERTAKEN BY A COMPETENT CONTRACTOR, WHO IS AWARE OF ALL GENERIC RISKS ASSOCIATED WITH THE WORKS. LISTED BELOW ARE 'SIGNIFICANT' RISKS RELATING TO THE WORKS.

NONE IDENTIFIED

A	PENSTOCK ADDED TO MH S1.2. NOTE 11 ADDED	RJA	CW	AUG 14
ISSUE	AMENDMENTS	DRAWN	CHECKED	DATE
CLIENT	 County Hall Haverfordwest Pembrokeshire SA61 1TP 01437 764551			
PROJECT	CRANE CROSS CIVIC AMENITY AND RECYCLING CENTRE SAUNDERSFOOT PEMBROKESHIRE			
TITLE	CIVIC AMENITY DRAINAGE LAYOUT			
PURPOSE	CONSTRUCTION			
CAPITA Property and Infrastructure St Davids House, Pascal Close, St Mellons, Cardiff, CF3 0LW T: 02920 803500 w: www.capita.co.uk/infrastructure Capita Property and Infrastructure Ltd.				
DRAWN	R J ARTHUR	DATE	MAR 2014	SCALE 1:250 @ A1
CHECKED	A G BARUGH	DATE	MAR 2014	PROJECT No. CS/071529
DRG. No.	CS/071529/C/502			REVISION REF. A