


LON HEN FELIN

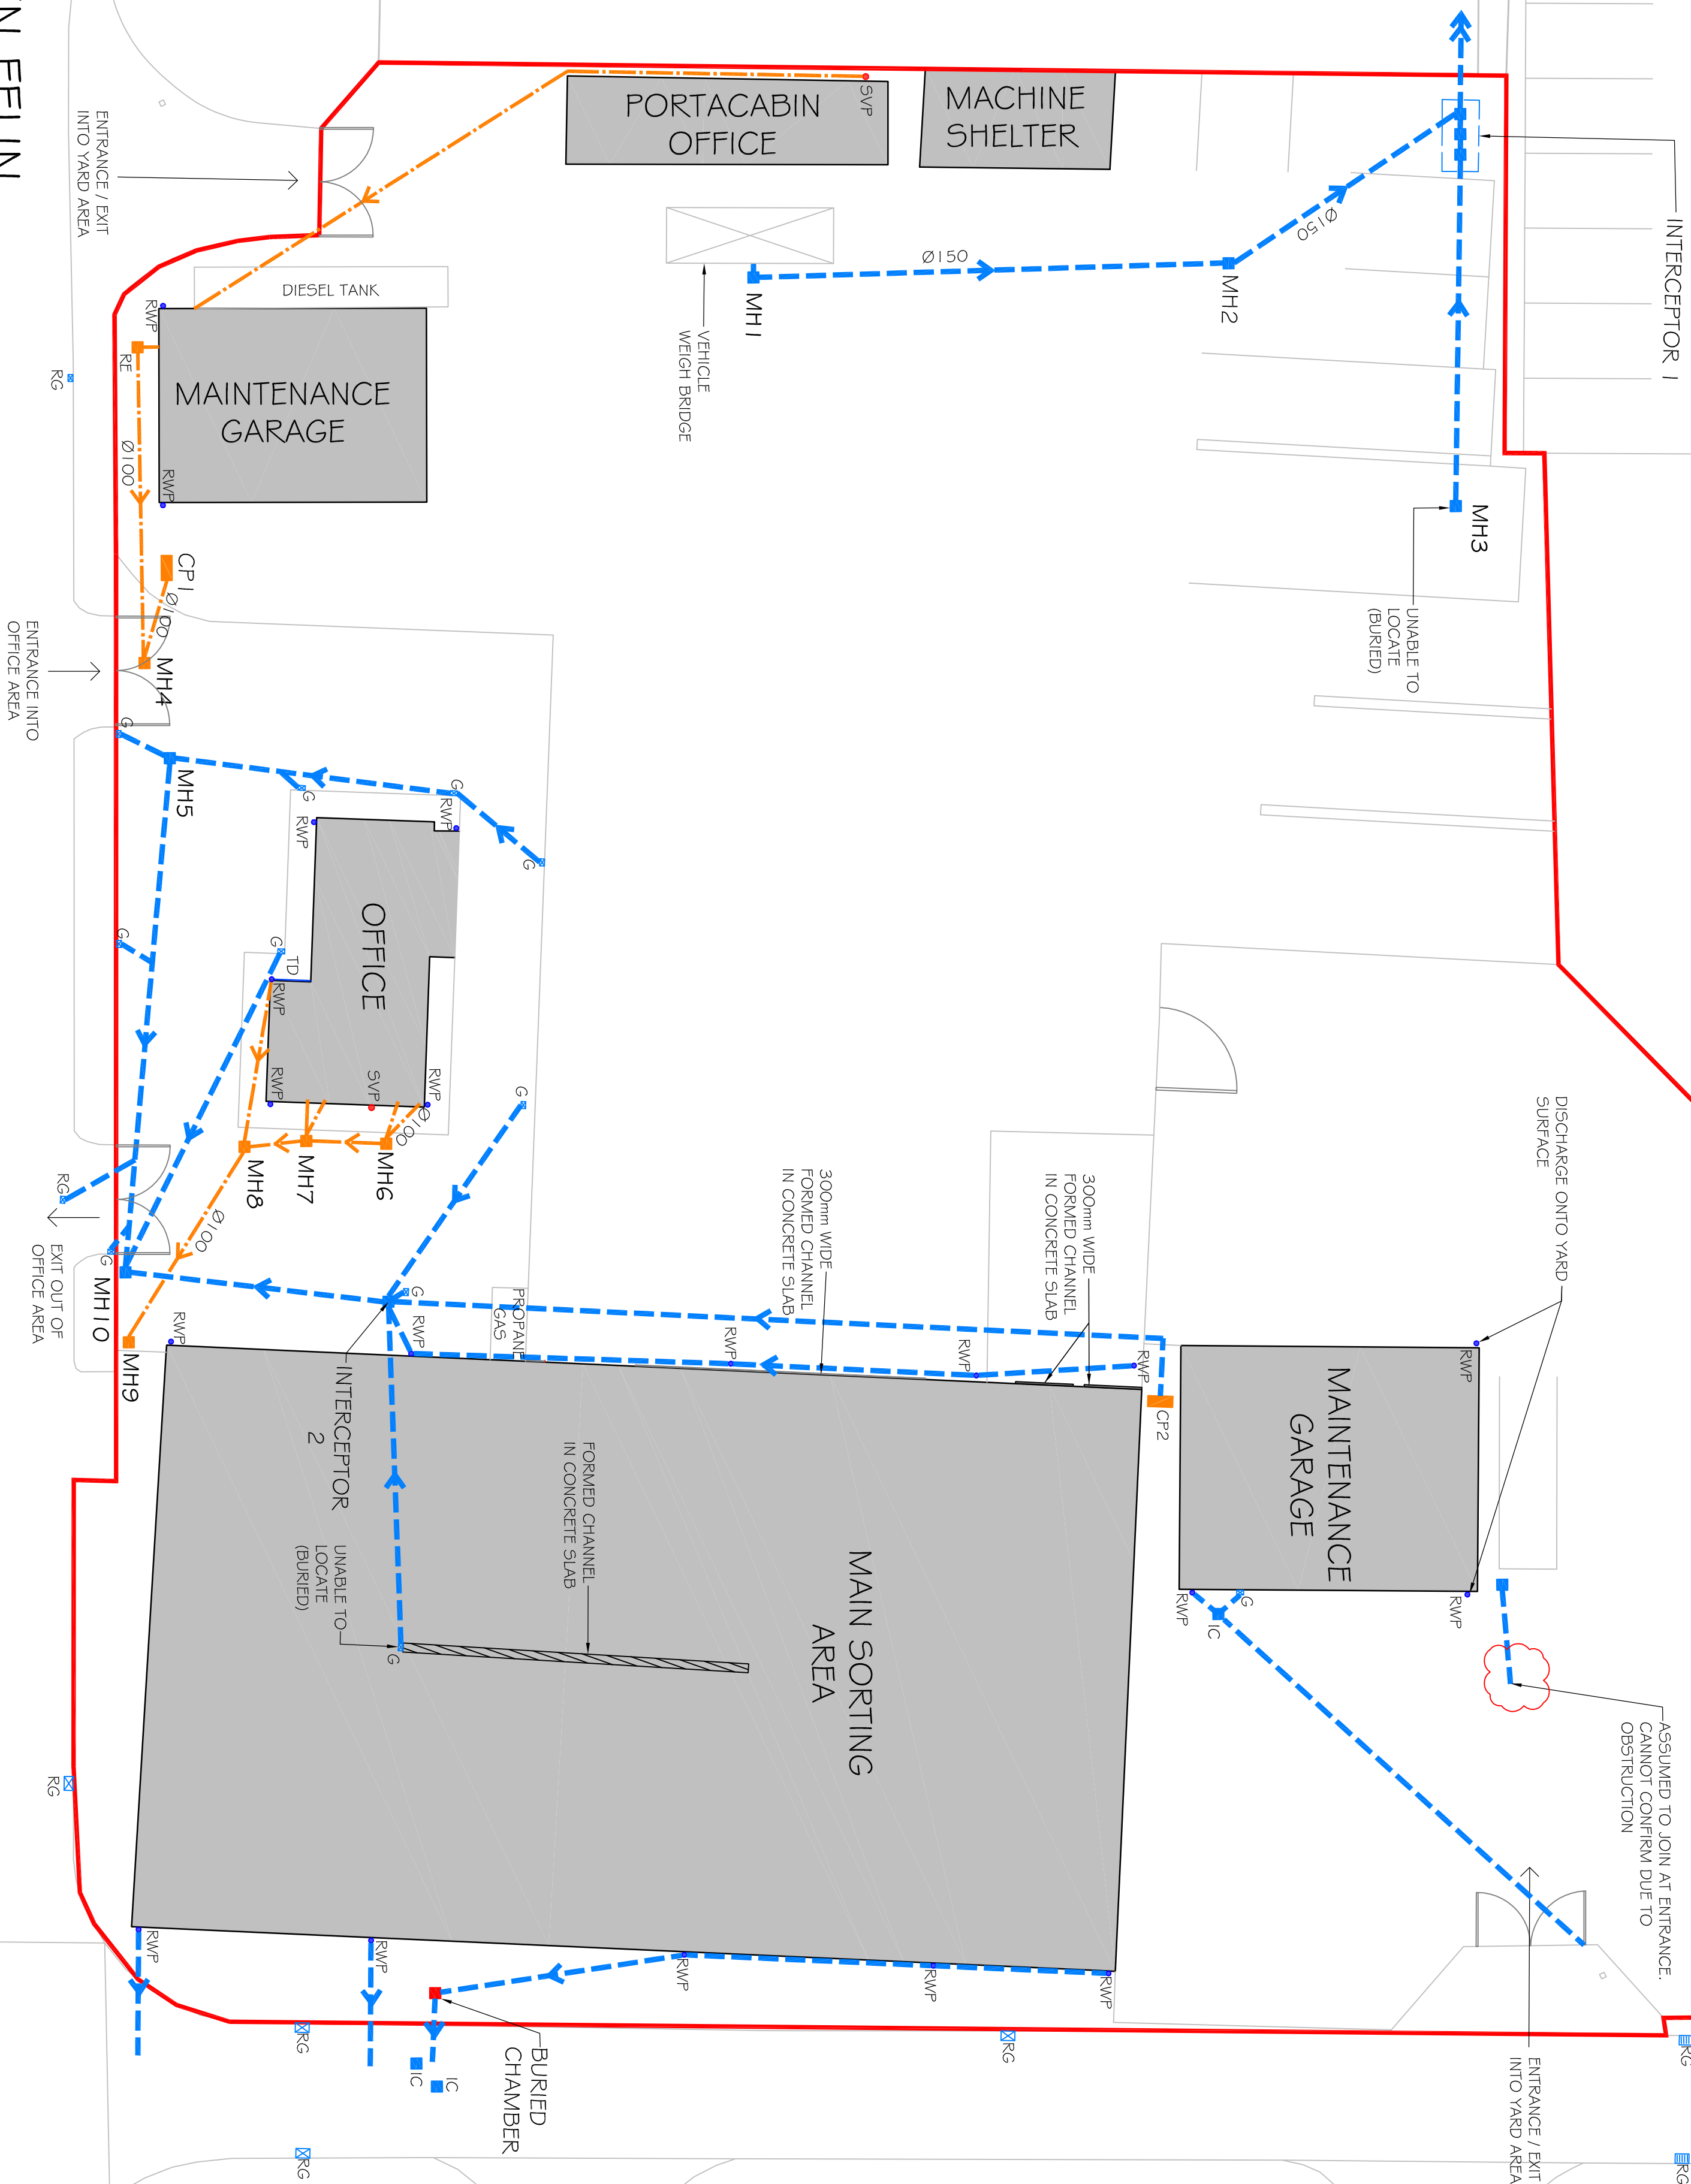

NOTES

THE DRAINAGE SHOWN ON THIS DRAWING IS AN INDICATIVE REPRESENTATION FROM THE FINDINGS OF GEWS Ltd DRAINAGE SURVEY ON 06/10/2016. CAULMERT Ltd CANNOT GUARANTEE THE DRAINAGE SHOWN ON THIS DRAWING AS WE HAVE NOT UNDERTAKEN A FULL DRAINAGE SURVEY ON SITE. THEREFORE GEWS Ltd SURVEY SHOULD BE REFERRED TO FOR FURTHER INFORMATION.

LEGEND

- SITE BOUNDARY (TBC)
- SURFACE WATER DRAIN
- FOLL WATER DRAINAGE
- COMBINED WATER DRAINAGE
- ROAD GULLY
- GULLY
- SURFACE WATER MANHOLE
- FOLL WATER MANHOLE
- COMBINED WATER MANHOLE
- EXISTING BUILDING
- RAIN WATER PIPE
- SOIL VENT PIPE
- CATCHPIT
- THRESHOLD DRAINAGE

REV	MODIFICATIONS	BY	RE	AP	DATE

PROJECT:

GWYNEDD SKIP & PLANT HIRE

TITLE:

EXISTING DRAINAGE LAYOUT

DRAWN BY	DATE	
RWG	06.10.2016	
REVIEWED BY	SCALE @ A1	JOB REF.
DM	1:250	2889
AUTHORISED BY	ISSUE	REVISION
DM	S2	P1

DRAWING NUMBER

2889-CAU-XX-OO-DR-6001



WWW.CAULMERT.COM

Registered Office: InTec, Parc Menai, Bangor, Gwynedd, LL57 4FG Company Registered No: 06716319